




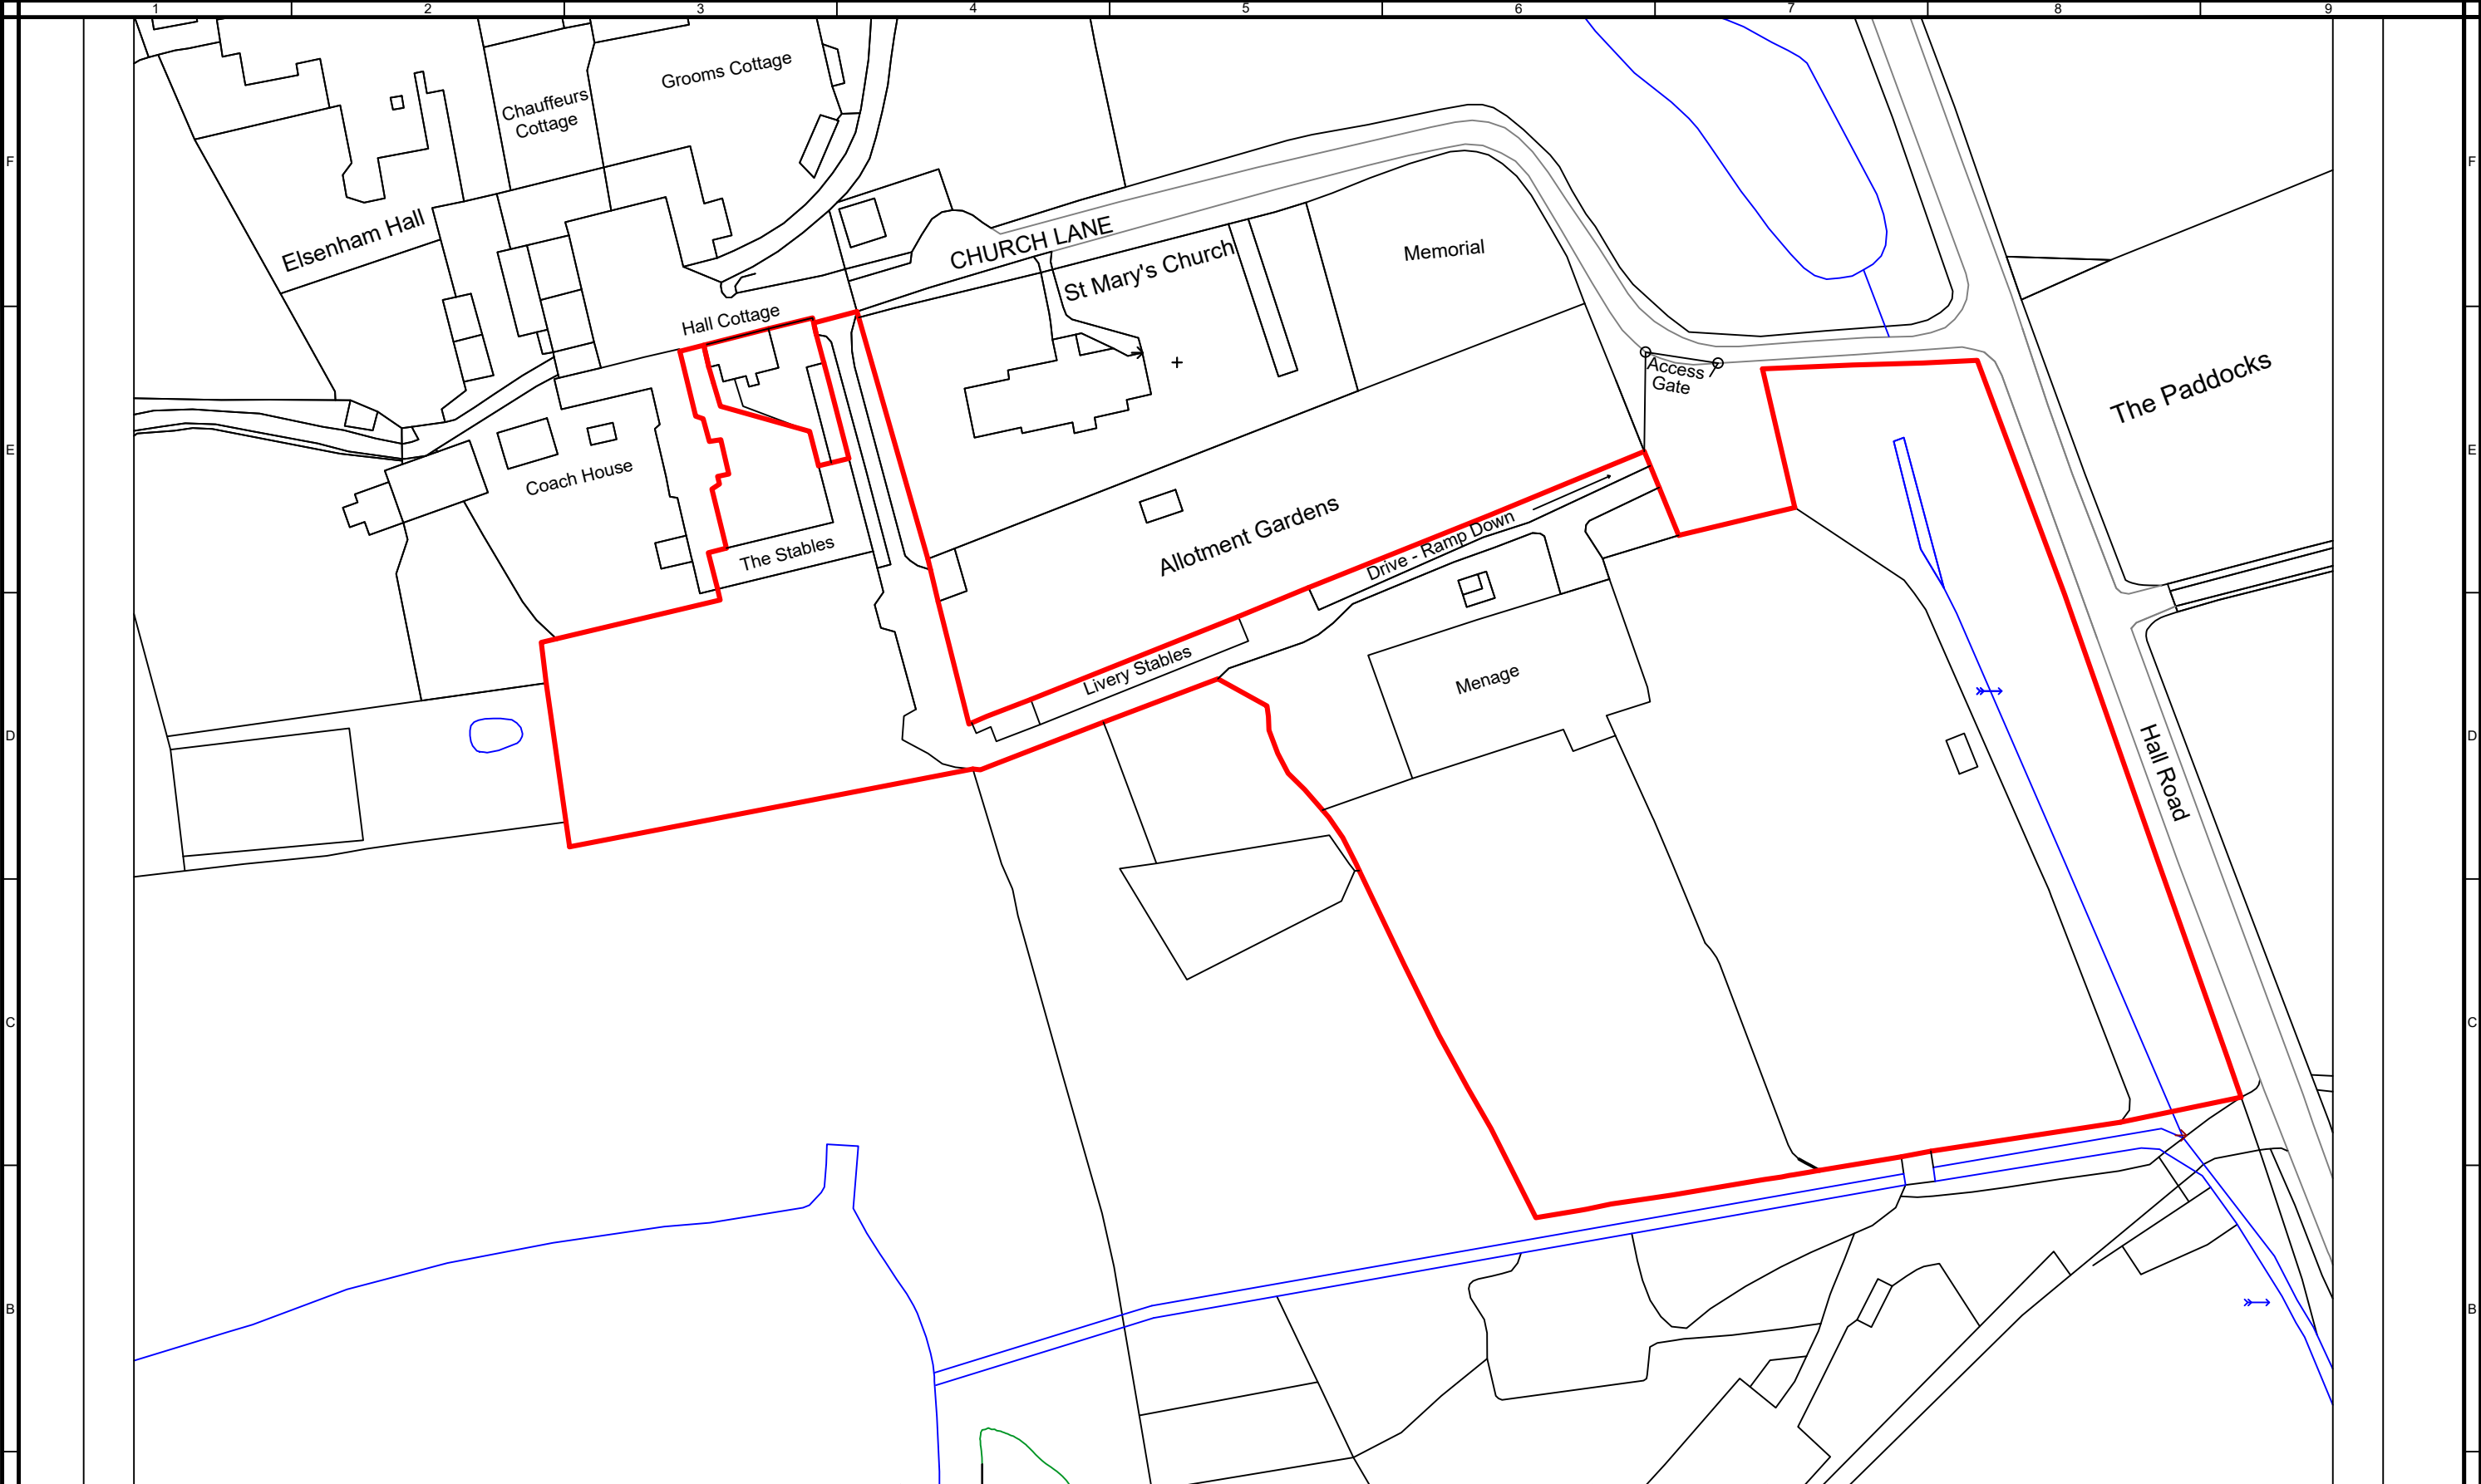


PROPOSED PLANS

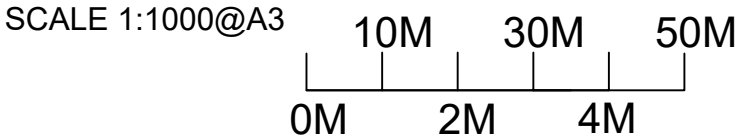


REV	DATE	REVISIONS	Drawing Title	Description	Project Address	INF	DETAILS	CONTRACTOR
A								
B								
C								
D								
E								
F								
G								
			Site Location Plan (Land Owned Area Outlined Red)	Earthwork Land Build Up & Land Drainage	The Stables Elsenham	Scale 1:1000@A3	TDH	SX - ARCHITECTURE
						Drawn By		
						Checked By B/I		
						Checked By Client	~	
						Date		
						Drawing Number		
						TheStablesSiteLocPin01		

THIS DRAWING IS THE COPYRIGHT OF SX-ARCHITECTURAL SERVICES AND MUST NOT BE COPIED OR REPRODUCED, IN WHOLE OR IN PART, BY ANY METHOD WHATSOEVER, WITHOUT THE PRIOR WRITTEN APPROVAL OF SX-ARCHITECTURAL.

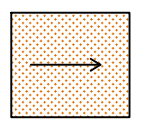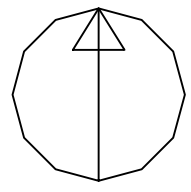


High
Sloped
Banking

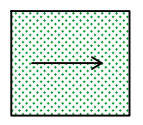

New
Grazed
Field


PROPOSED PLANS

SCALE 1:1000@A3

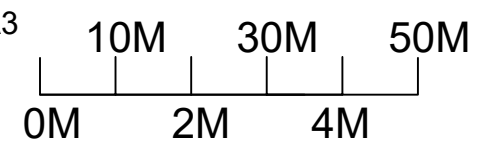


REV	DATE	REVISIONS
A		
B		
C		
D		
E		
F		
G		

Drawing Title	Description	Project Address	INF	DETAILS	CONTRACTOR
Proposed Site Area Plan Earthfill To Grazing Fields	Earthwork Land Build Up & Land Drainage	The Stables Elsenham			SX - ARCHITECTURE THIS DRAWING IS THE COPYRIGHT OF SX-ARCHITECTURAL SERVICES AND MUST NOT BE COPIED OR REPRODUCED, IN WHOLE OR IN PART, BY ANY METHOD WHATSOEVER, WITHOUT THE PRIOR WRITTEN APPROVAL OF SX-ARCHITECTURAL.
			Scale	1:1000@A3	
			Drawn By	TDH	
			Checked By B/I		
			Checked By Client	~	
			Date		
			Drawing Number TheStablesPropSitePin01		

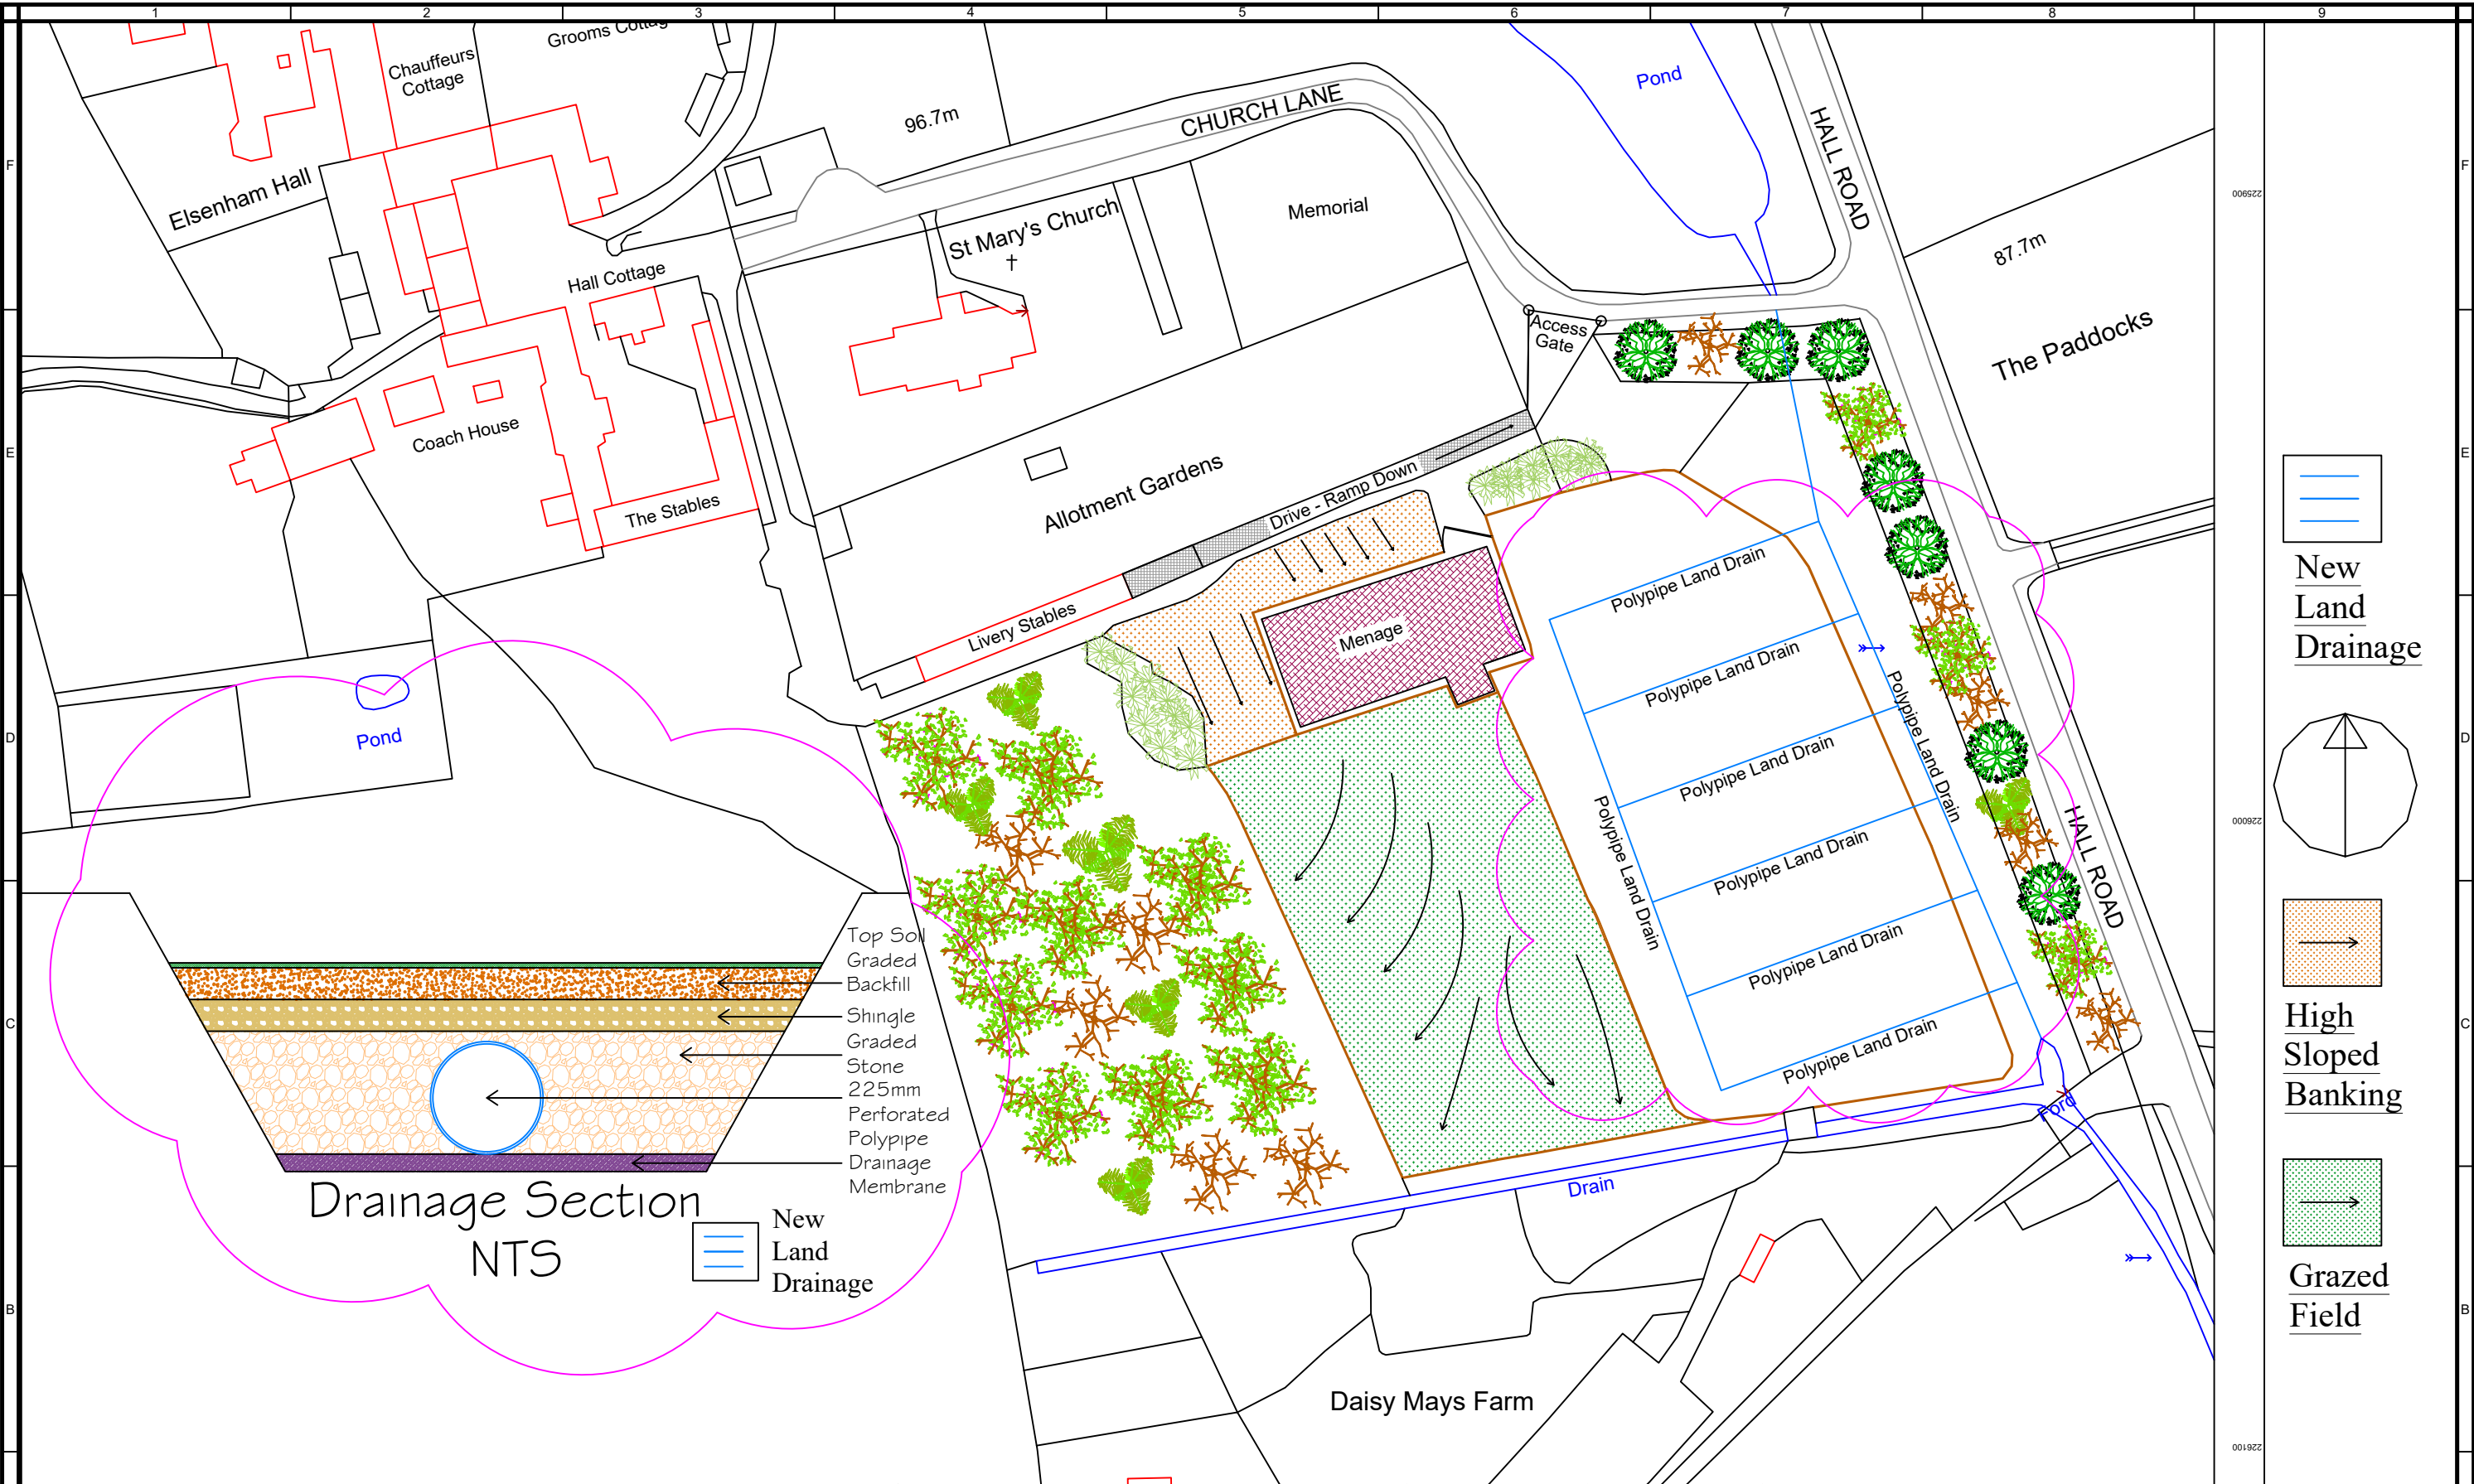

- New Land Drainage
- North Arrow
- High Sloped Banking
- Grazed Field

PROPOSED PLANS


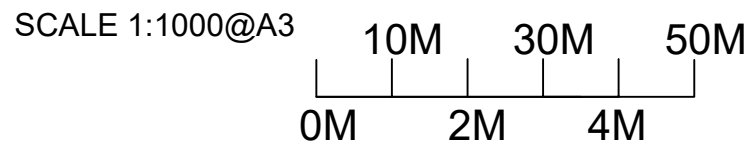


REV	DATE	REVISIONS
A		
B		
C		
D		
E		
F		
G		


Drawing Title	Description	Project Address
Land Drain Layout Plan	Drain Build Up & Land Drainage	The Stables Elsenham

INF	DETAILS	CONTRACTOR
Scale	1:1000@A3	SX - ARCHITECTURE
Drawn By	TDH	
Checked By B/I		
Checked By Client	~	
Date		
Drawing Number TheStables-DrainPln01		



THIS DRAWING IS THE COPYRIGHT OF SX-ARCHITECTURAL SERVICES AND MUST NOT BE COPIED OR REPRODUCED, IN WHOLE OR IN PART, BY ANY METHOD WHATSOEVER, WITHOUT THE PRIOR WRITTEN APPROVAL OF SX-ARCHITECTURAL.

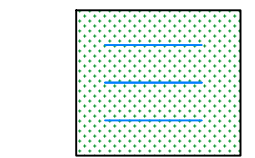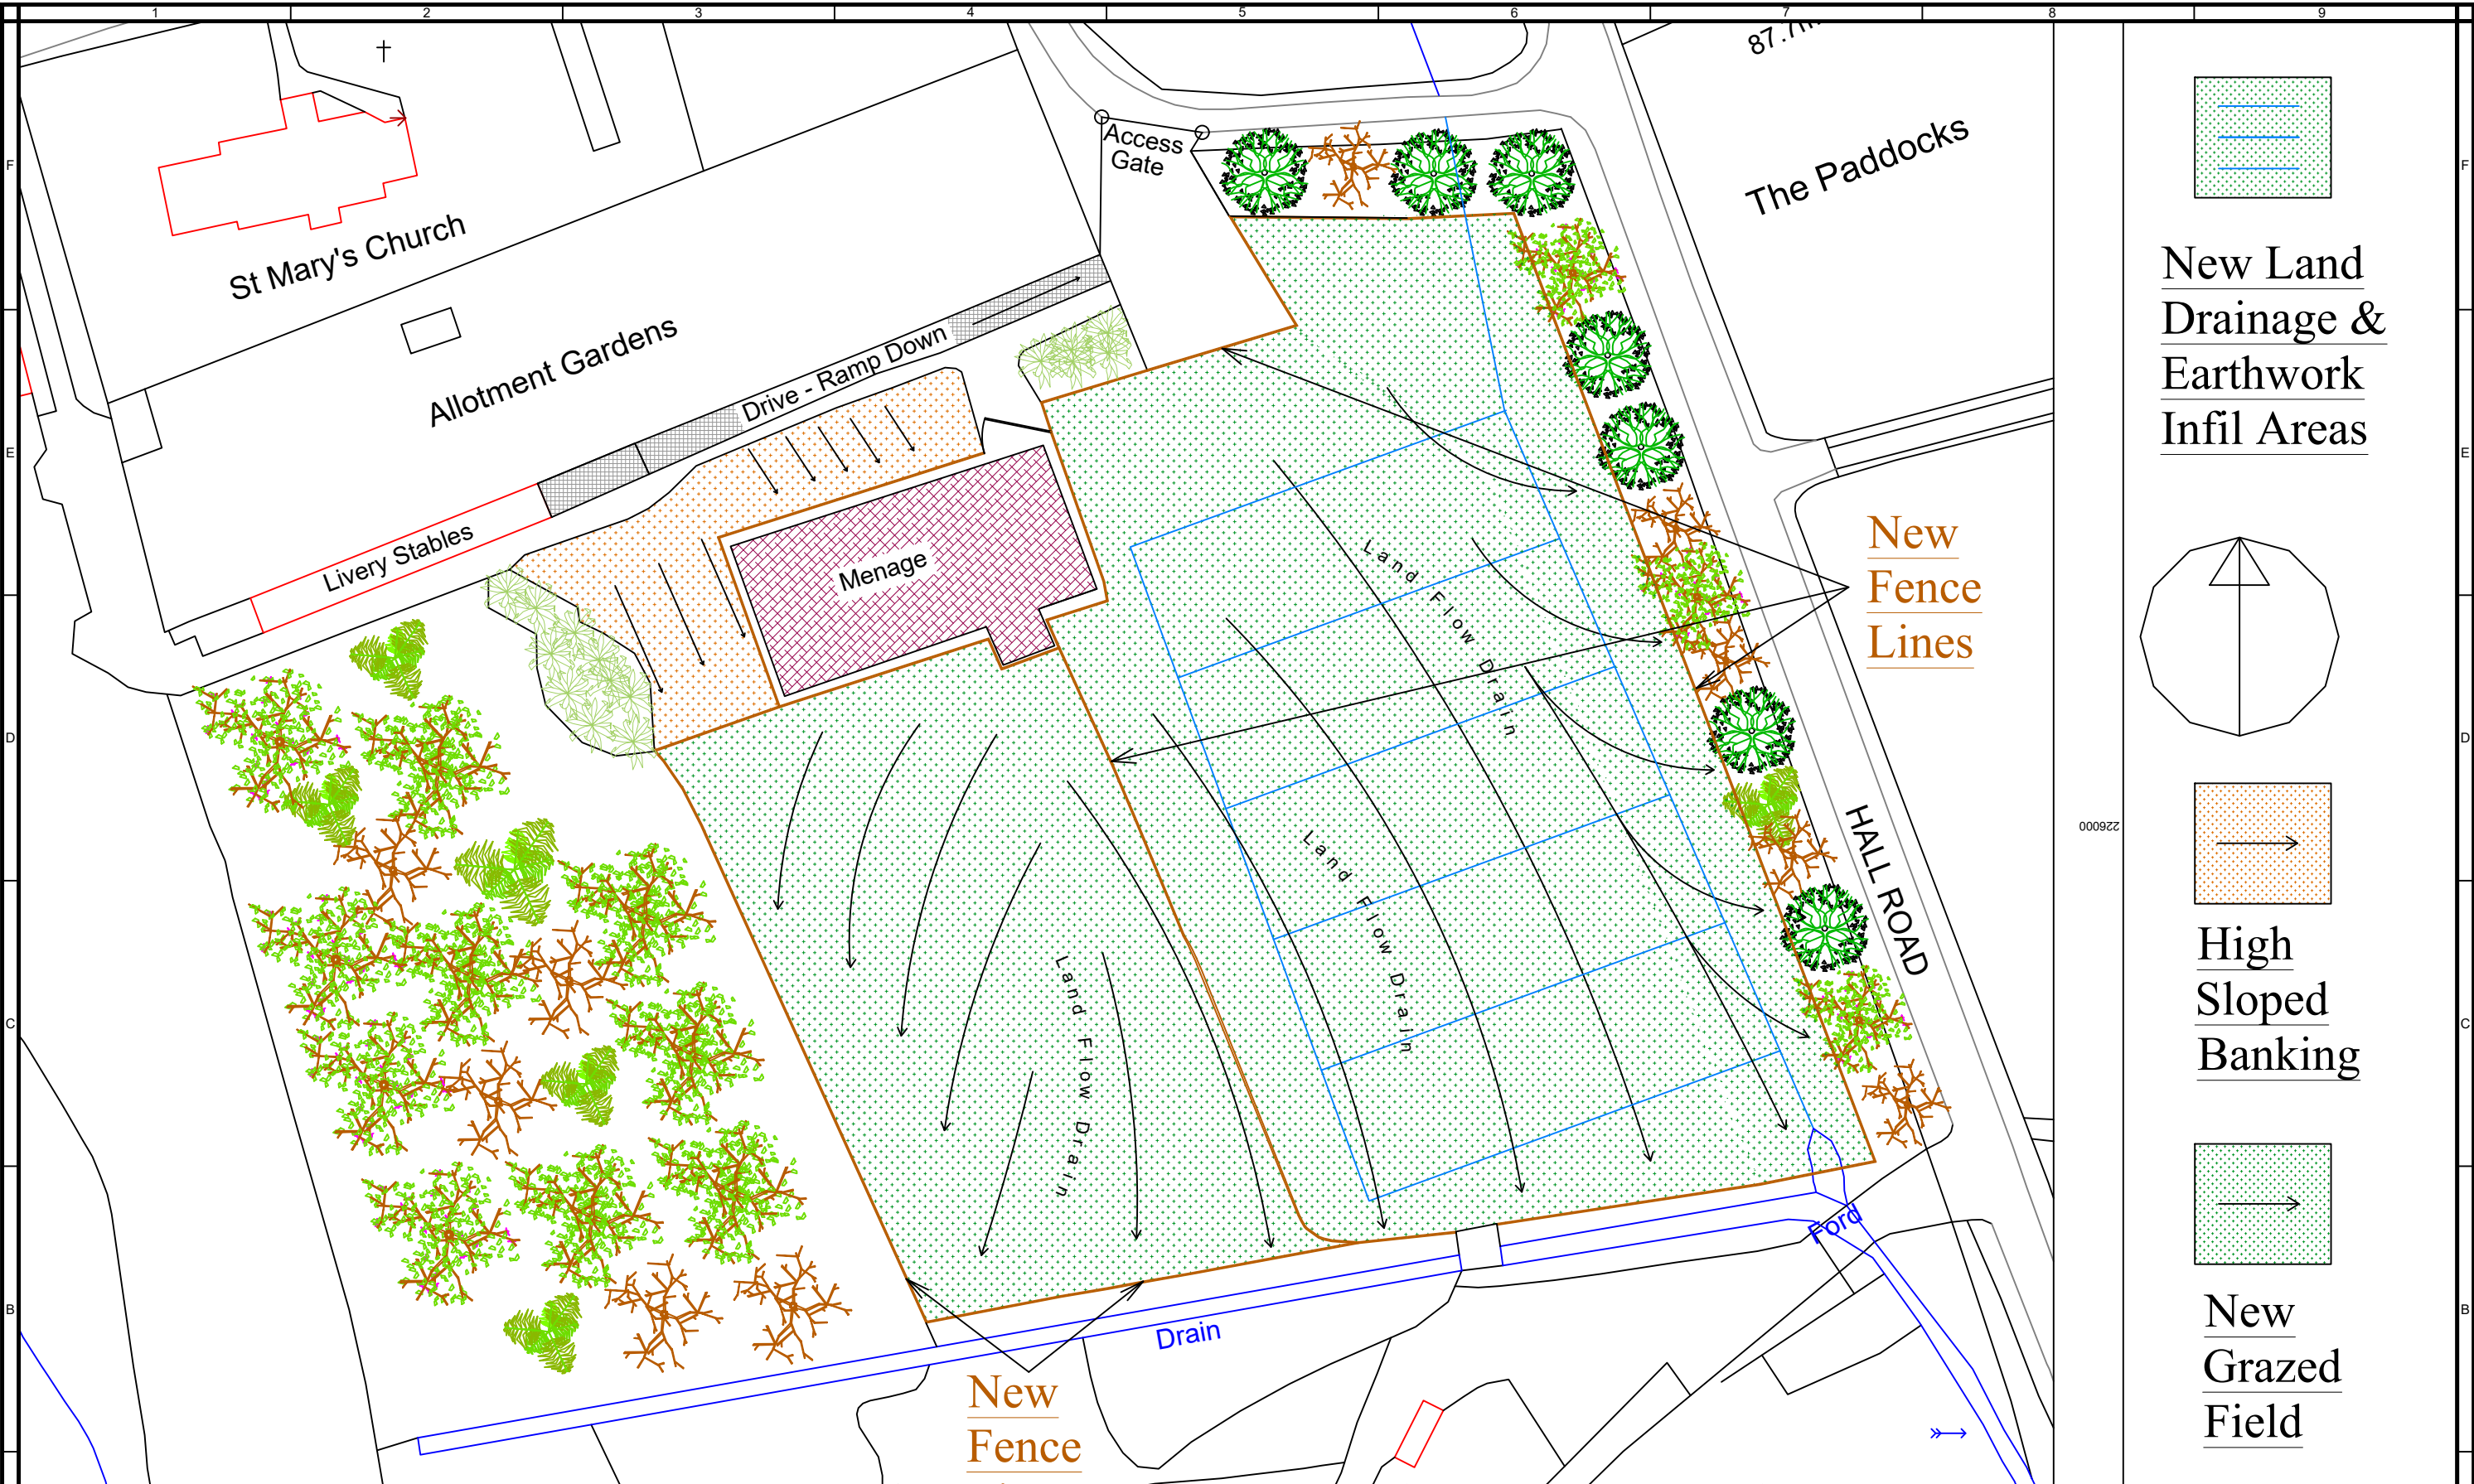

New Land
Drainage &
Earthwork
Infil Areas

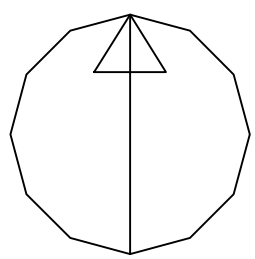


High
Sloped
Banking

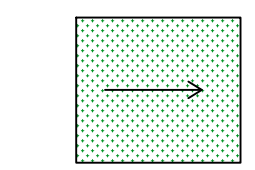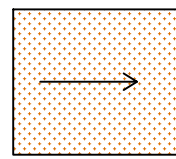

New
Grazed
Field

PROPOSED PLANS

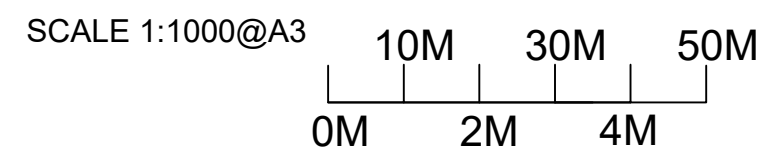


REV	DATE	REVISIONS
A		
B		
C		
D		
E		
F		
G		

Drawing Title	Description	Project Address
Earthfill & Drainage Layout to Grazing Fields	Earthwork Land Build Up & Land Drainage	The Stables Elsenham


INF	DETAILS
Scale	NTS
Drawn By	TDH
Checked By B/I	
Checked By Client	~
Date	
Drawing Number TheStablesDrainPln02	

CONTRACTOR
<u>SX - ARCHITECTURE</u>

THIS DRAWING IS THE COPYRIGHT OF SX-ARCHITECTURAL SERVICES AND MUST NOT BE COPIED OR REPRODUCED, IN WHOLE OR IN PART, BY ANY METHOD WHATSOEVER, WITHOUT THE PRIOR WRITTEN APPROVAL OF SX-ARCHITECTURAL.

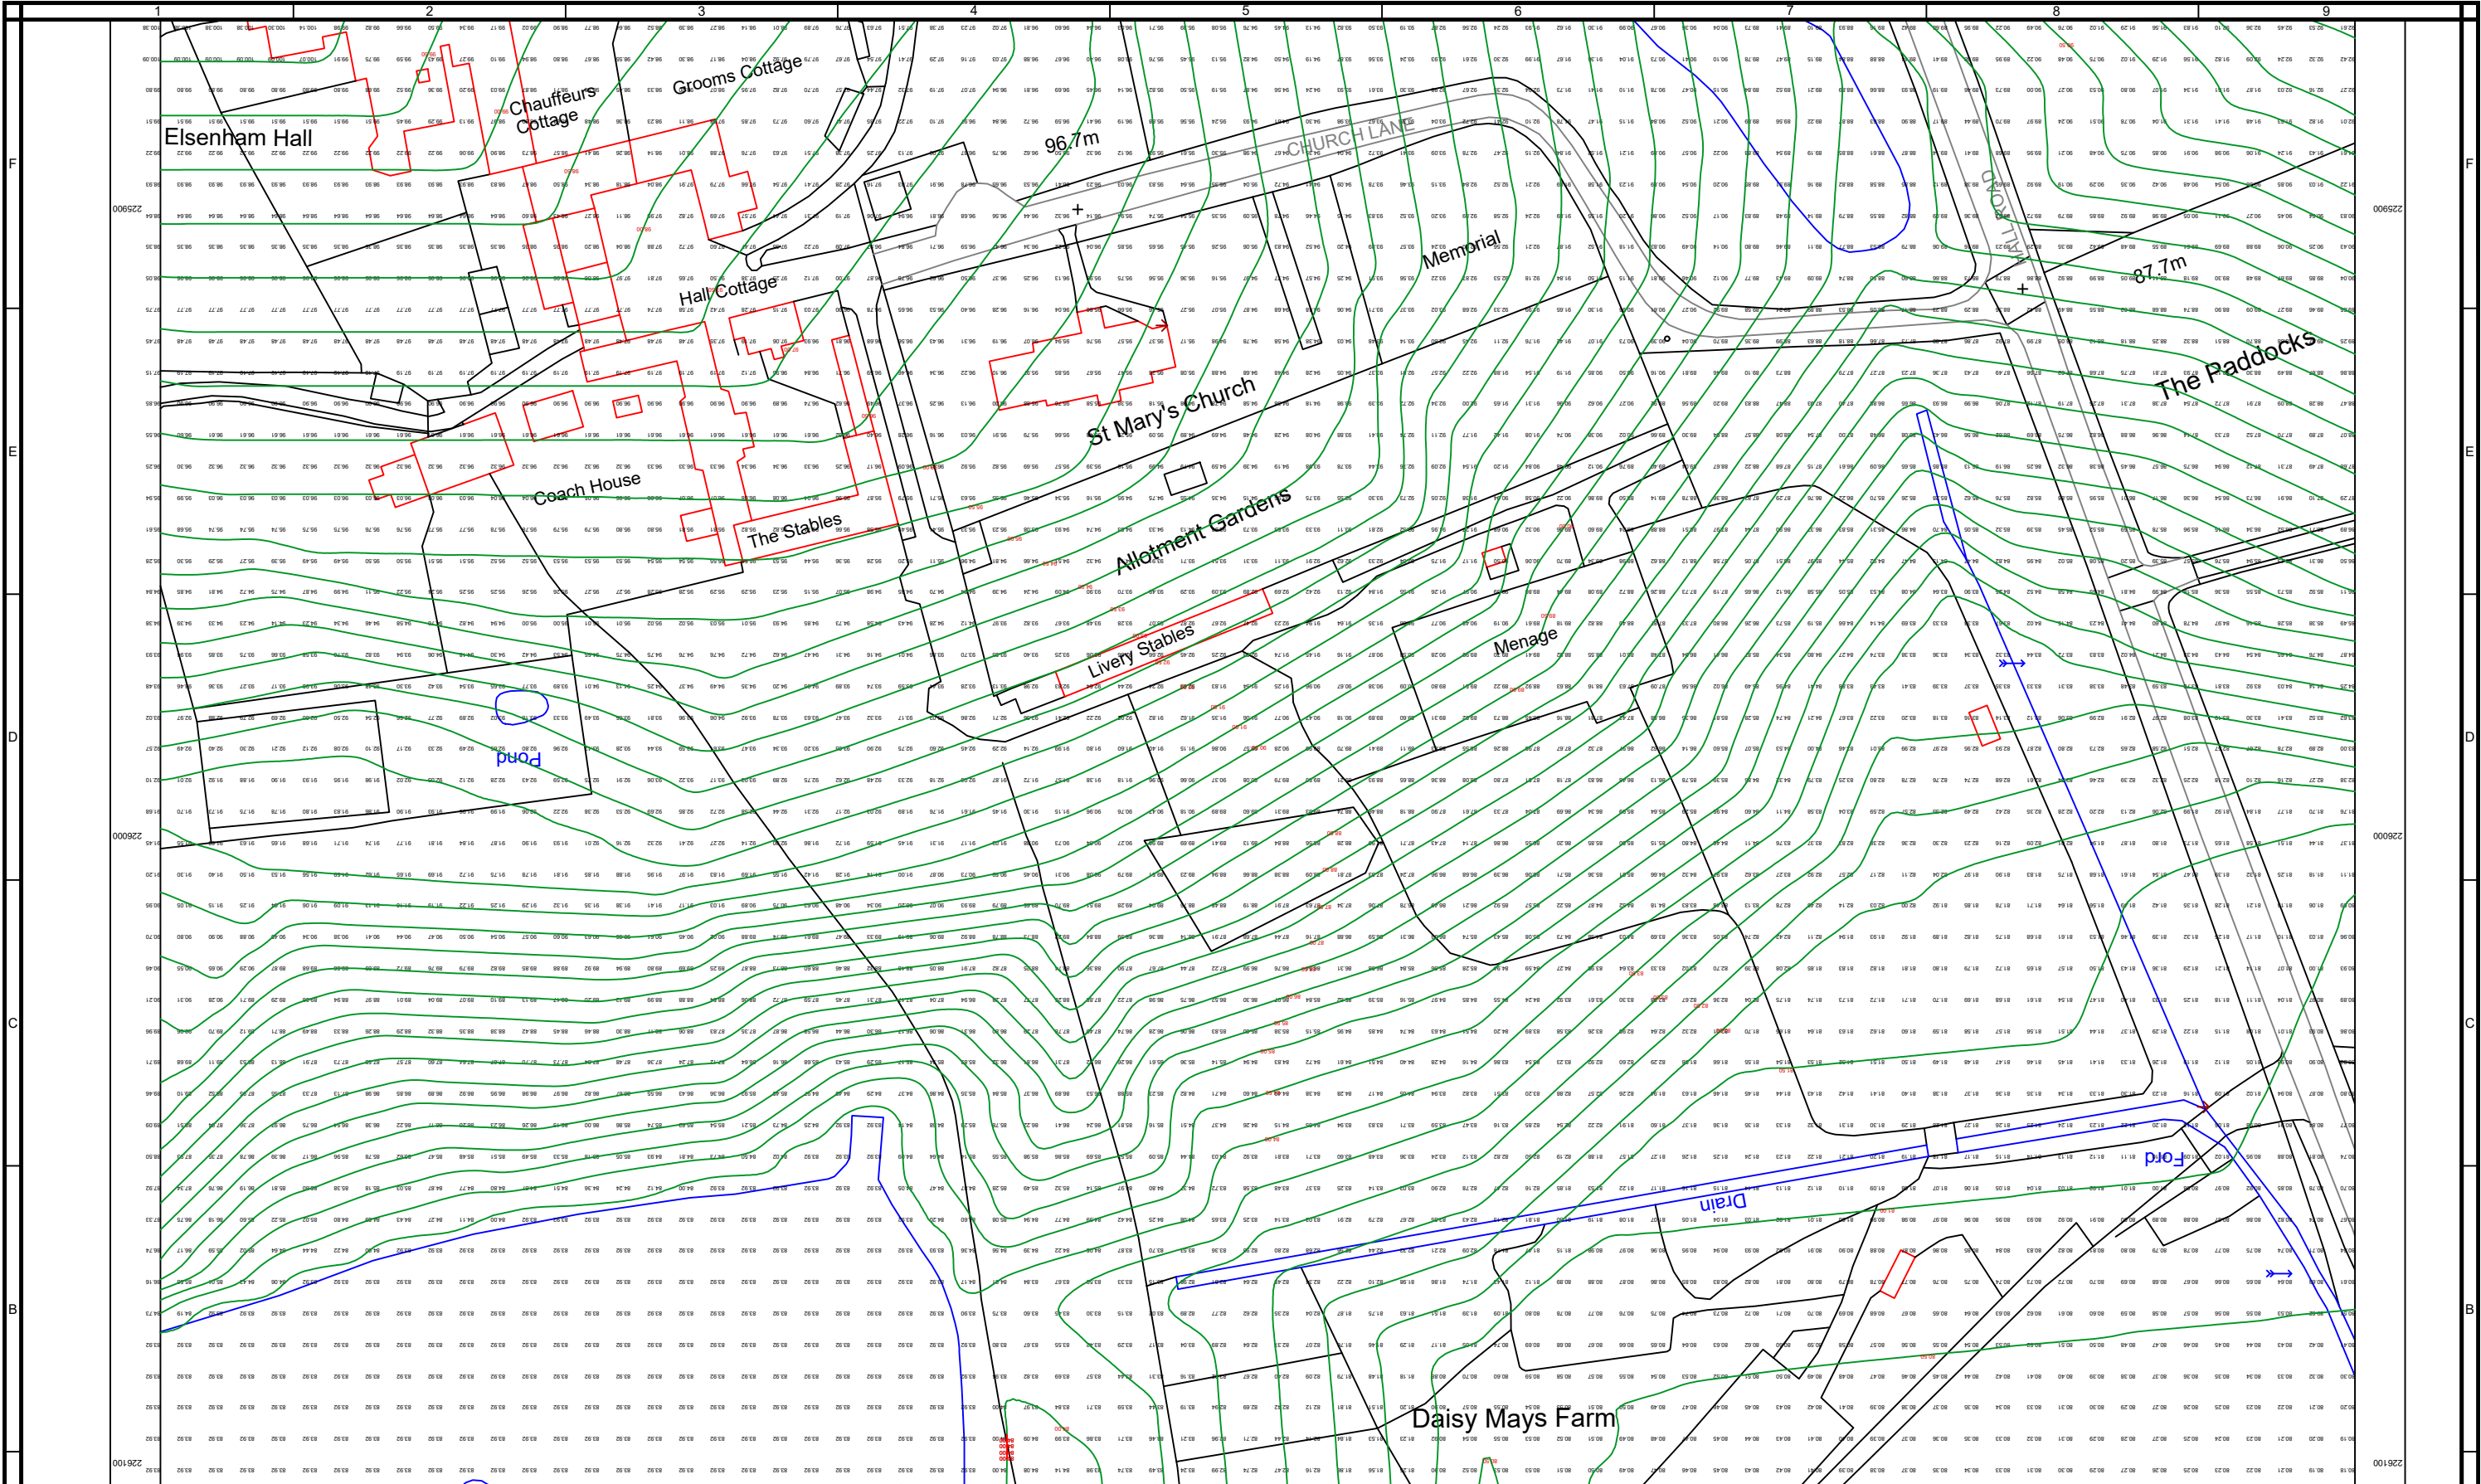


EXISTING TOPOLOGY SITE PLAN

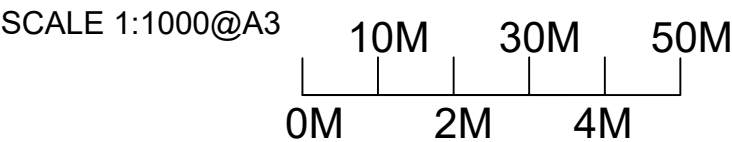


REV	DATE	REVISIONS
A		
B		
C		
D		
E		
F		
G		

Drawing Title	Description	Project Address	INF	DETAILS	CONTRACTOR
Existing Site Topology Plan	Earthwork Land Build Up & Land Drainage	The Stables Elsenham	Scale 1:1000@A3	TDH	SX - ARCHITECTURE
			Drawn By		
			Checked By B/I		
			Checked By Client		
			Date		THIS DRAWING IS THE COPYRIGHT OF SX-ARCHITECTURAL SERVICES AND MUST NOT BE COPIED OR REPRODUCED, IN WHOLE OR IN PART, BY ANY METHOD WHATSOEVER, WITHOUT THE PRIOR WRITTEN APPROVAL OF SX-ARCHITECTURAL.
			Drawing Number		
			ExistTopologySitePlan-01		

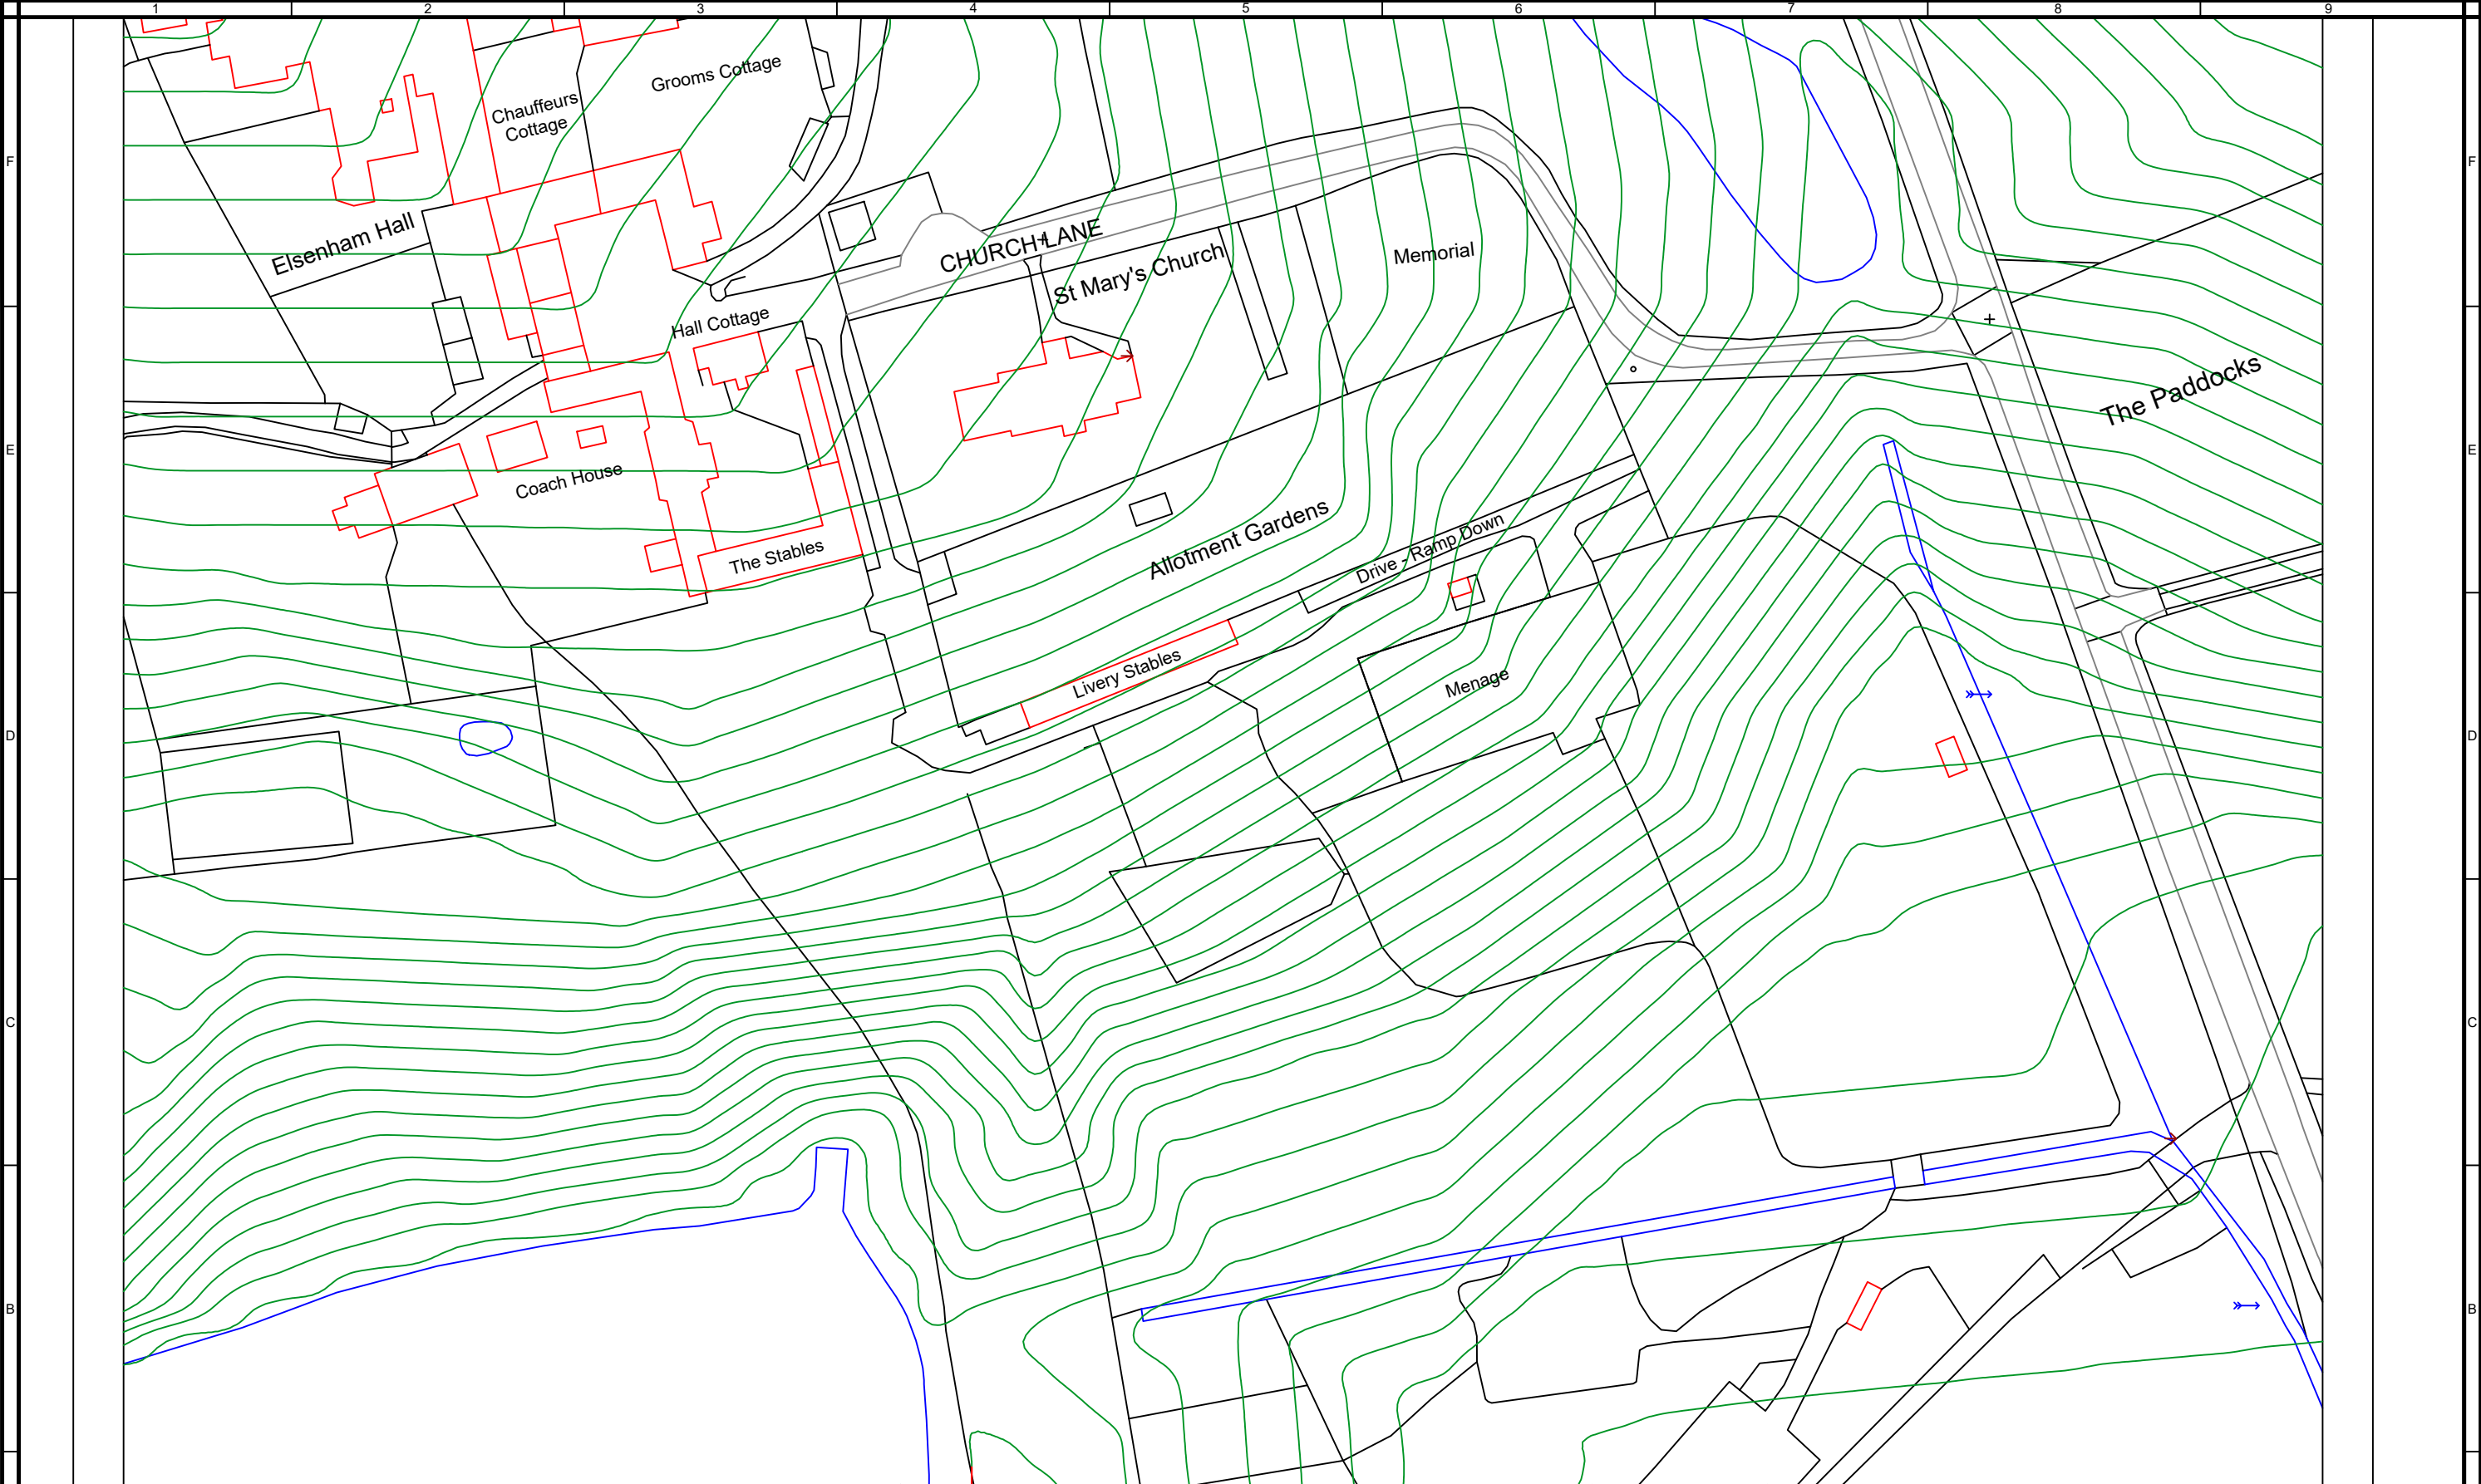

EXISTING TOPOLOGY SITE PLAN

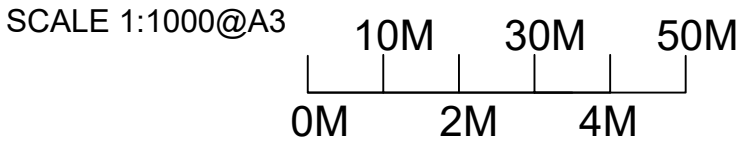

REV	DATE	REVISIONS
A		
B		
C		
D		
E		
F		
G		

Drawing Title	Description	Project Address
Existing Site Topology Plan	Earthwork Land Build Up & Land Drainage	The Stables Elsenham

INF	DETAILS	CONTRACTOR
Scale	1:1000@A3	SX - ARCHITECTURE
Drawn By	TDH	
Checked By B/I		
Checked By Client	~	
Date		
Drawing Number ExistTopologySitePln02		THIS DRAWING IS THE COPYRIGHT OF SX-ARCHITECTURAL SERVICES AND MUST NOT BE COPIED OR REPRODUCED, IN WHOLE OR IN PART, BY ANY METHOD WHATSOEVER, WITHOUT THE PRIOR WRITTEN APPROVAL OF SX-ARCHITECTURAL.