


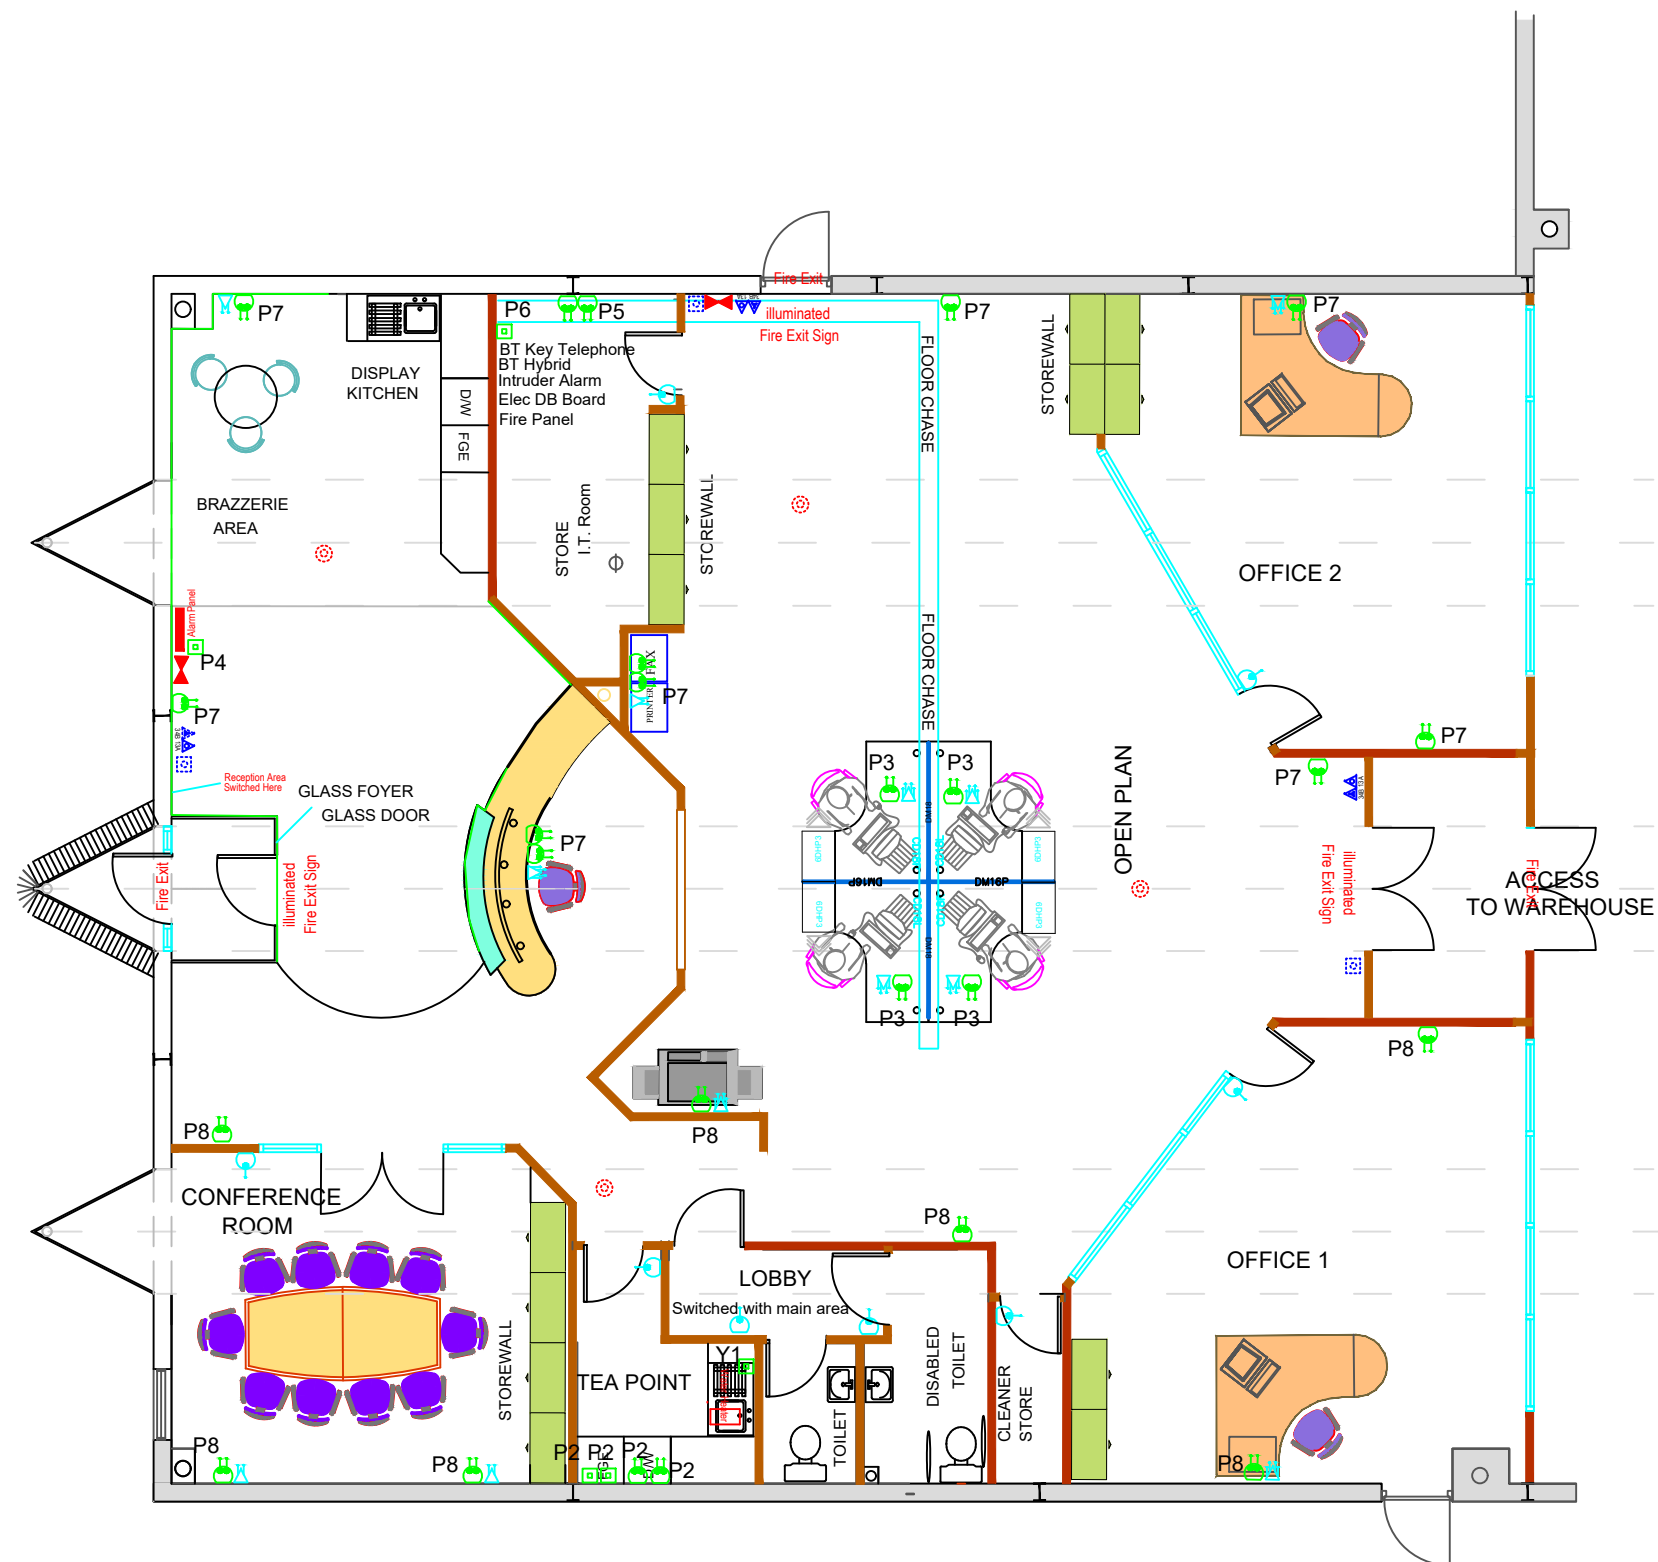

-  Double Socket Outlet
 -  Fused Spur
 -  Single Switching
 -  Quad Data Outlet
 -  Double Data Outlet
 -  Call Point
 -  Smoke Detector
 -  Sounder
 -  Fire Fighting Equipment - CO2
 -  Fire Fighting Equipment - Water
- P7** Electrical Power Circuits



REV	DATE	REVISIONS	Drawing Title	Description	Project Address	INF	DETAILS	CONTRACTOR
A			Small Power Layout Plan		Basildon Office	Scale	NTS	SX  ARCHITECTURE enquiries@sxarchitecture.co.uk THIS DRAWING IS THE COPYRIGHT OF SX-ARCHITECTURE AND MUST NOT BE COPIED OR REPRODUCED, IN WHOLE OR IN PART, BY ANY METHOD WHATSOEVER, WITHOUT THE PRIOR WRITTEN APPROVAL OF SX-ARCHITECTURE.
B						Drawn By	TDH	
C						Checked By B/I	TDH	
D						Checked By Client	~	
E						Date		
F						Drawing Number		
G						Pw&LghtPLan01		

Key

✕ 600 x 600 Light Unit
Category 2 Diffusers

⊕ 12v Low Voltage Downlight

⊕E 12v Low Voltage Eyeball

● CCT Flash Downlight


EXIT Fire Exit Lighted Sign

EM Emergency Lighting

⊙ Smoke Detector

Heating and Cooling Unit
Air Condition Unit

C 1 Electrical Lighting Circuits

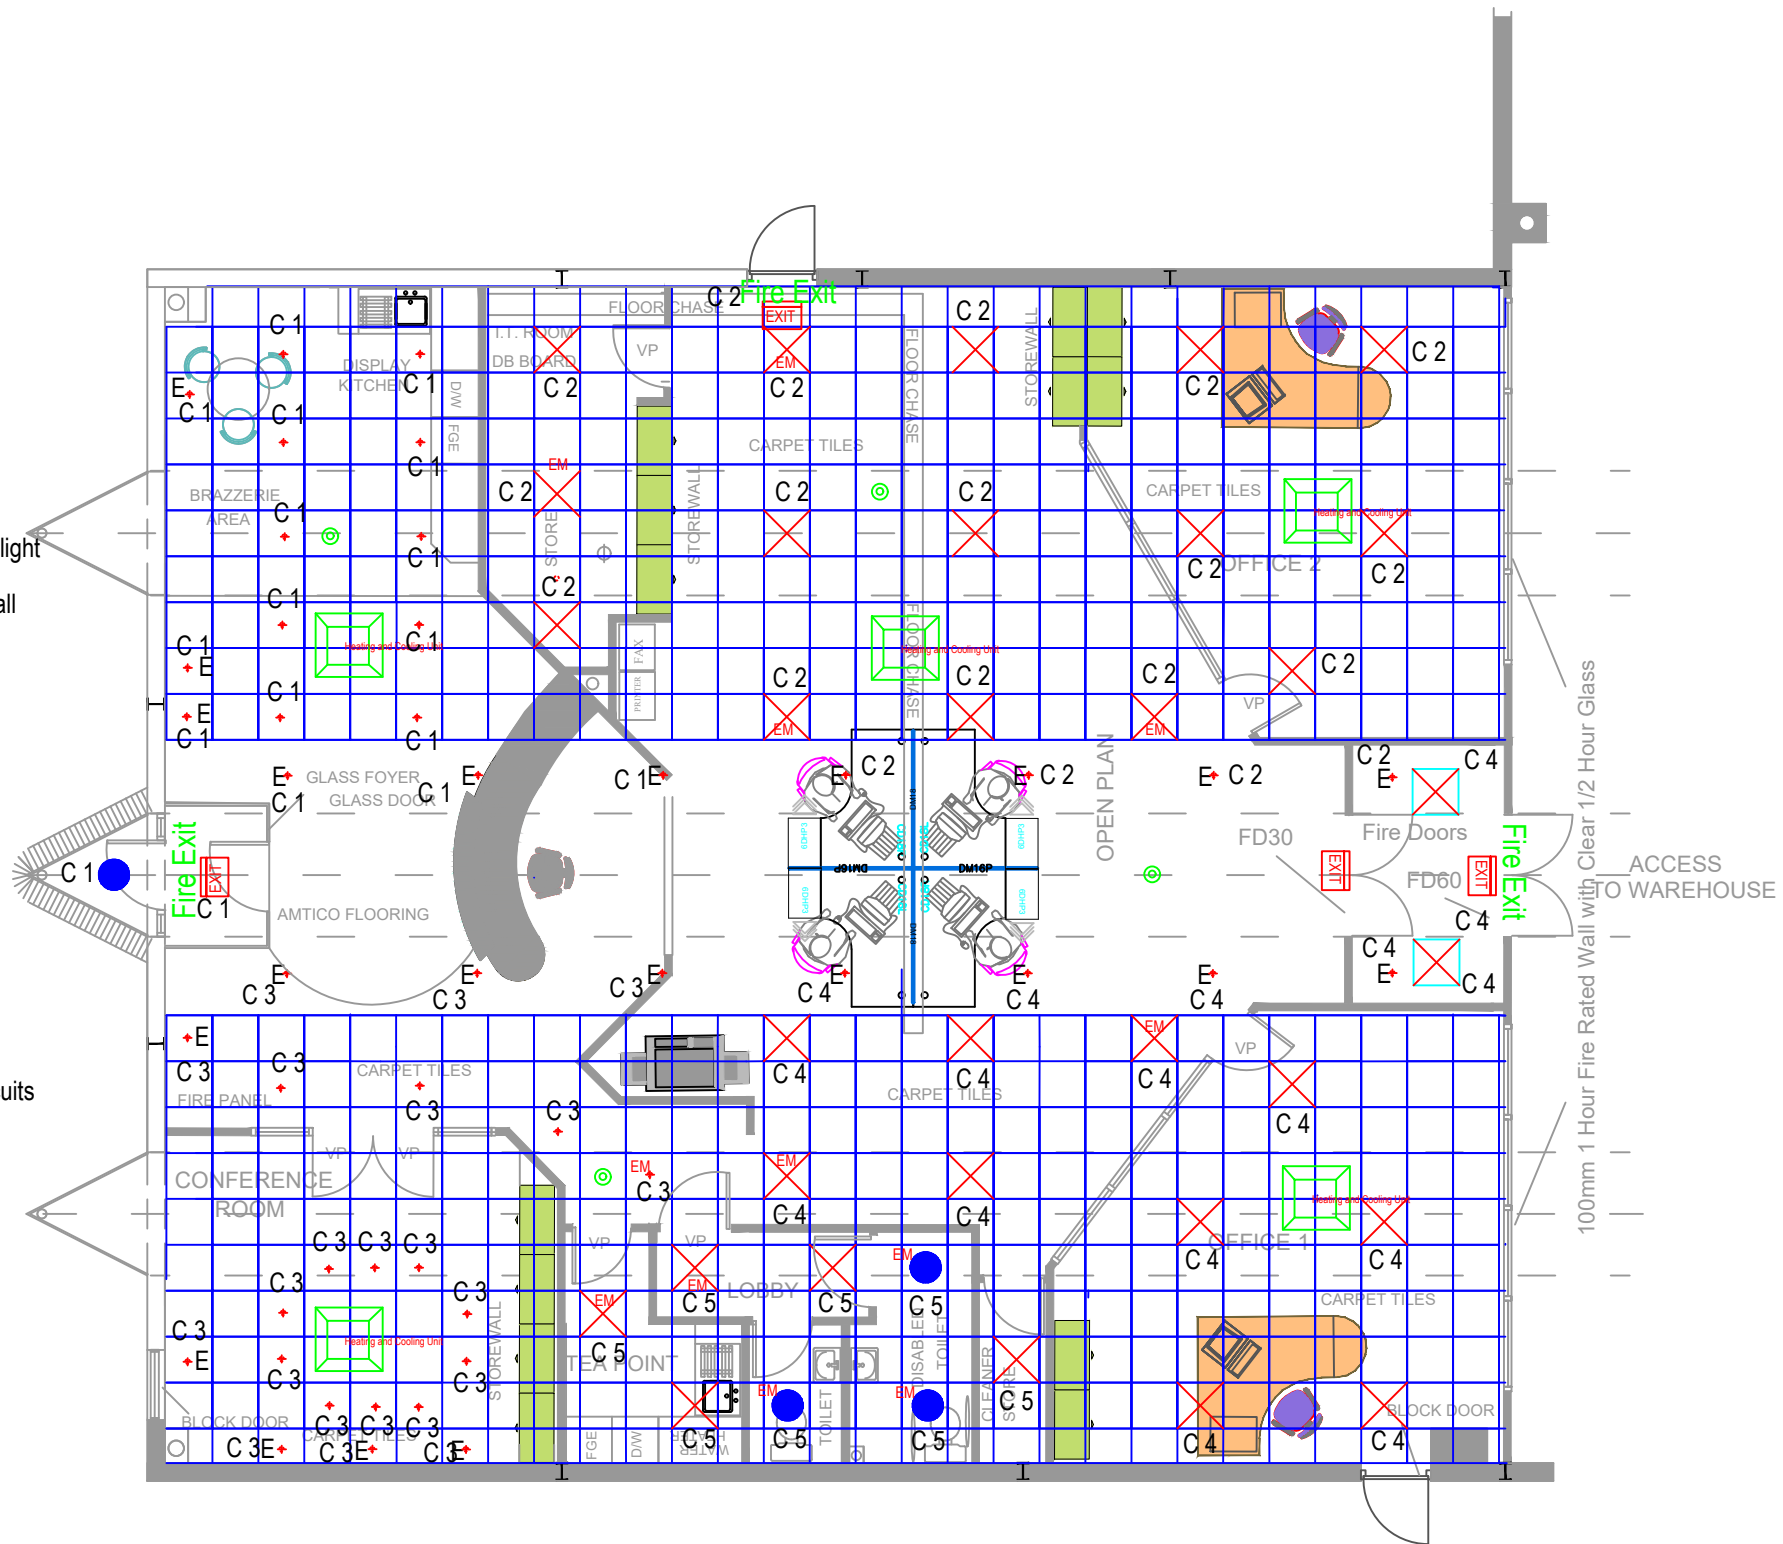

REV	DATE	REVISIONS	Drawing Title	Description	Project Address	INF	DETAILS	CONTRACTOR
A			Ceiling & Lighting Plan		Basildon Office	Scale	NTS	SX ARCHITECTURE enquiries@sxarchitecture.co.uk THIS DRAWING IS THE COPYRIGHT OF SX-ARCHITECTURE AND MUST NOT BE COPIED OR REPRODUCED, IN WHOLE OR IN PART, BY ANY METHOD WHATSOEVER, WITHOUT THE PRIOR WRITTEN APPROVAL OF SX-ARCHITECTURE.
B						Drawn By	TDH	
C						Checked By B/I	TDH	
D						Checked By Client	~	
E						Date		
F						Drawing Number	Pw&LghtPlan01	
G								