




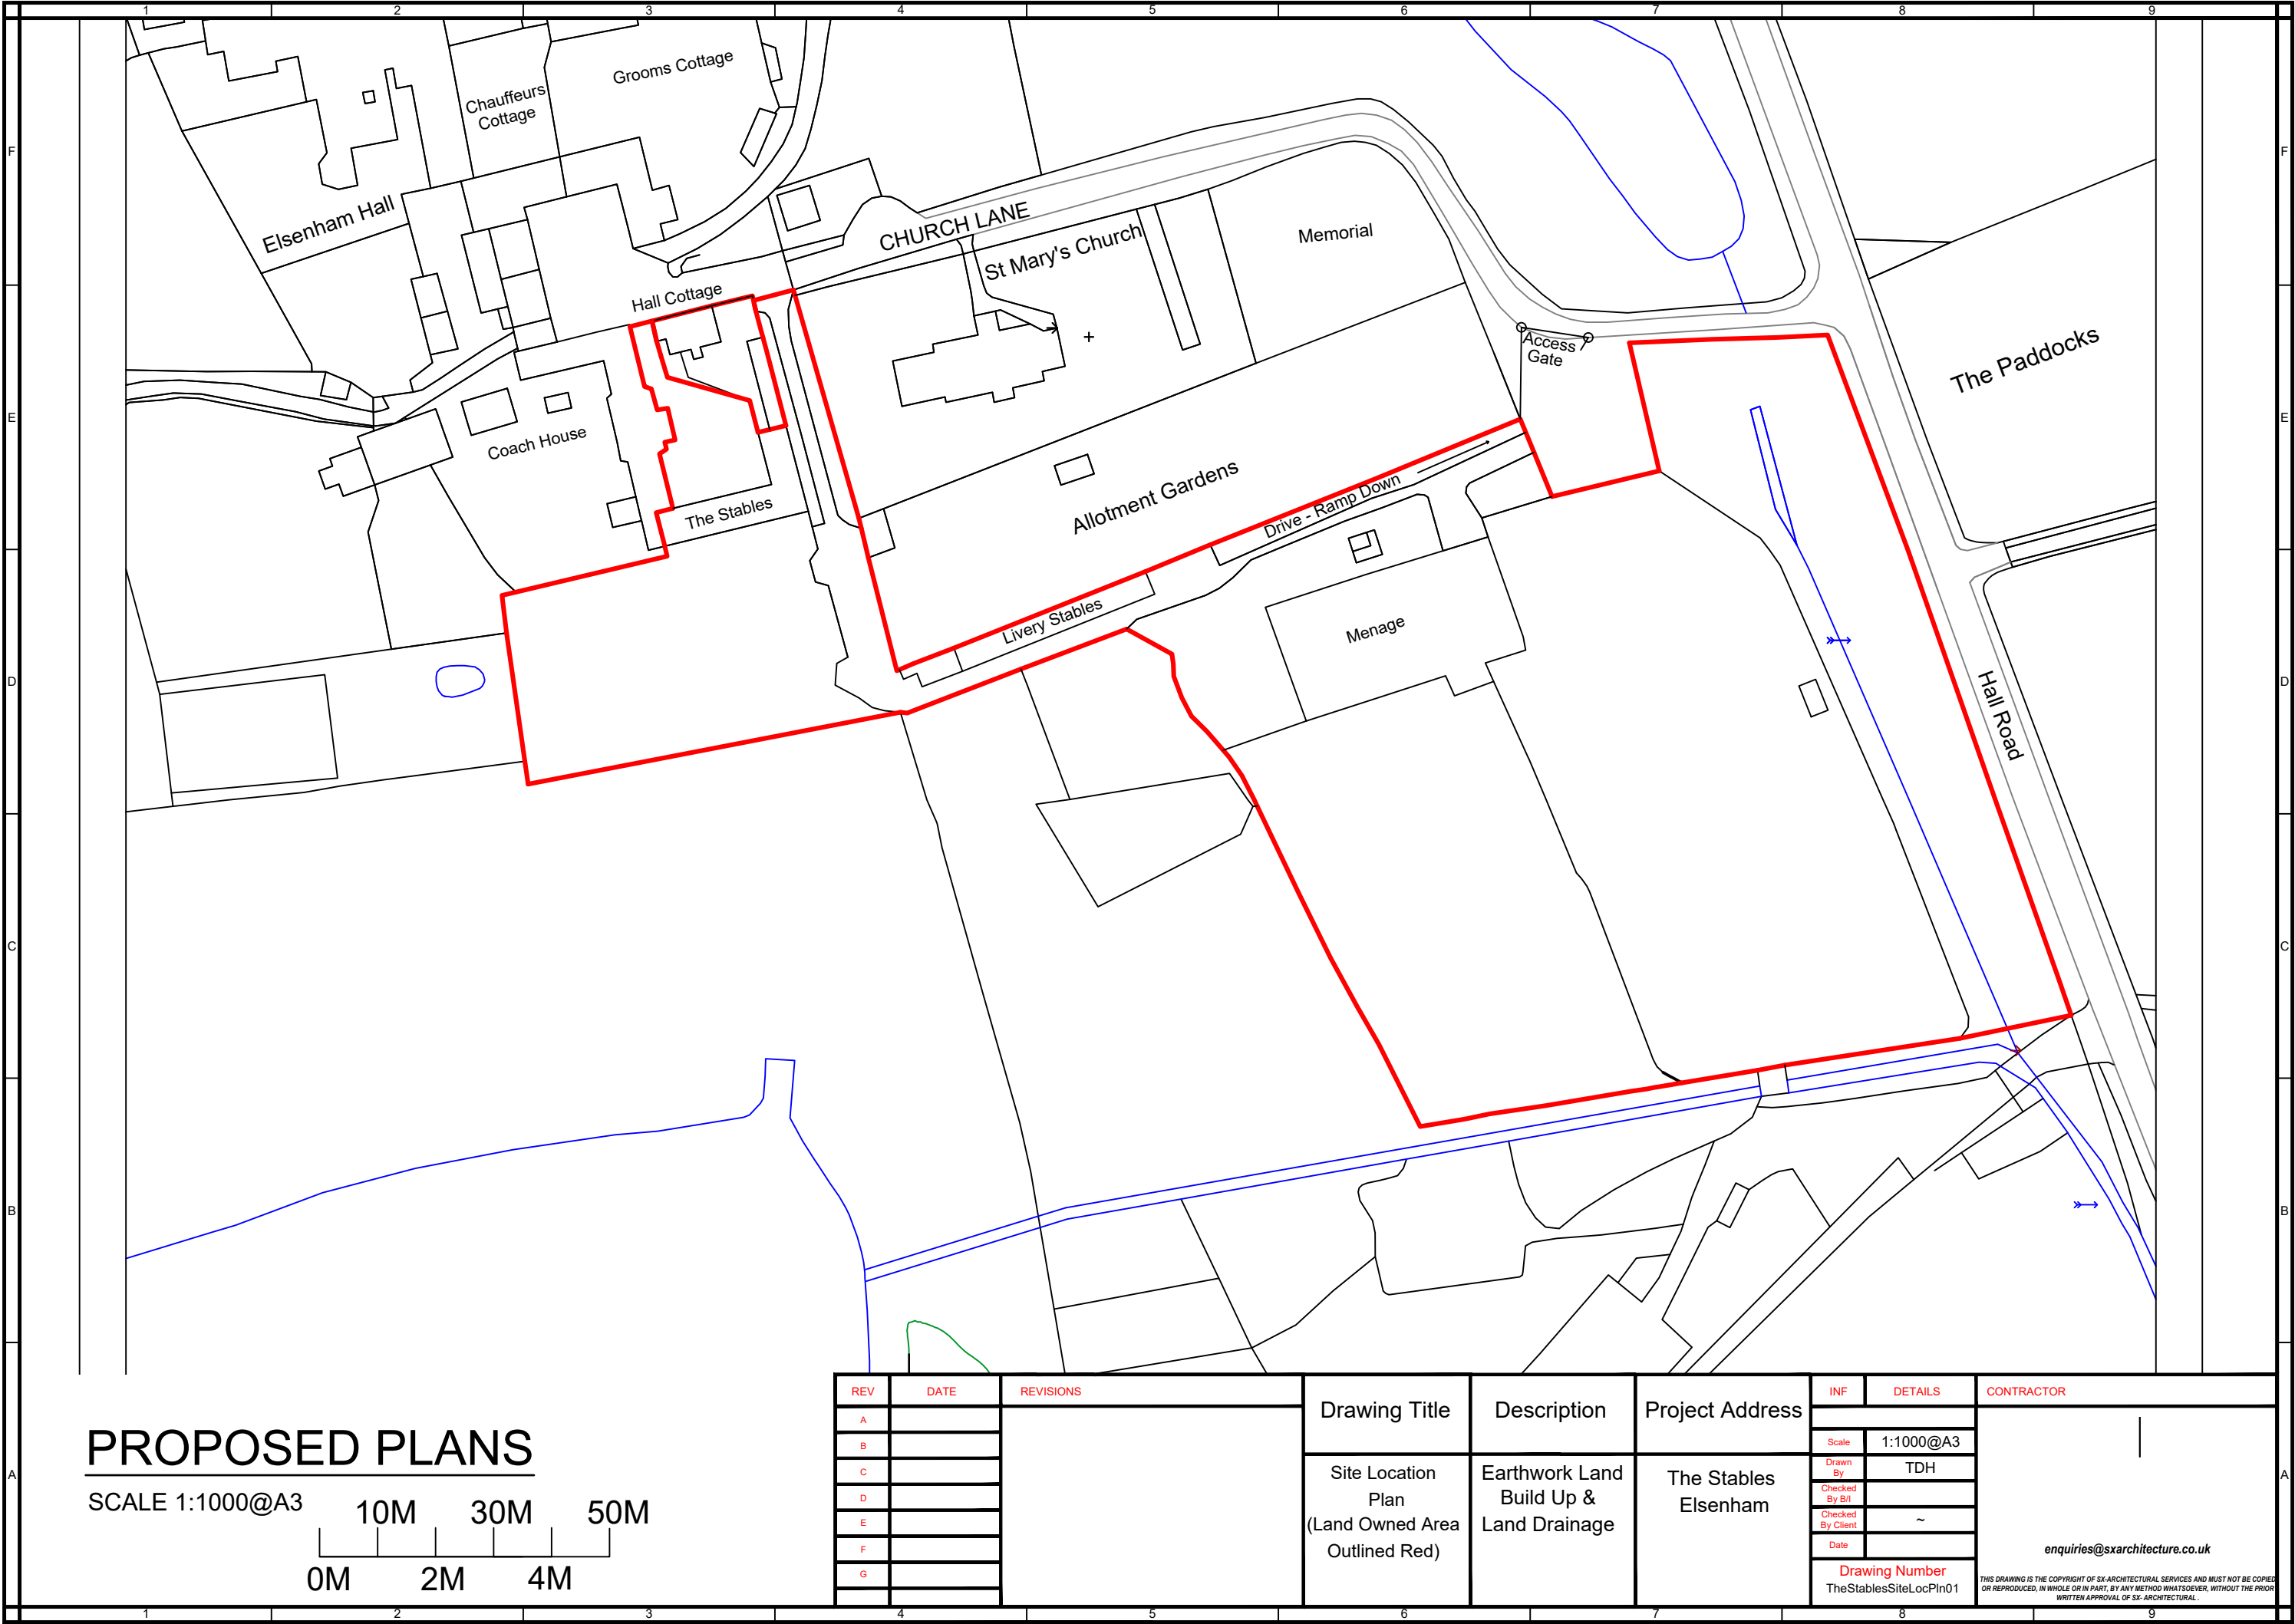


PROPOSED PLANS


SCALE 1:1000@A3
0M 10M 20M 30M 40M 50M

REV	DATE	REVISIONS	Drawing Title	Description	Project Address	INF	DETAILS	CONTRACTOR
A			Site Location Plan	Earthwork Land Build Up & Land Drainage	The Stables Elsenham	Scale	1:1000@A3	
B			(Land Owned Area Outlined Red)			Drawn By	TDH	
C						Checked By B/I		
D						Checked By Client	~	
E						Date		
F						Drawing Number		
G						TheStablesSiteLocPin01		

 enquiries@sxarchitecture.co.uk
THIS DRAWING IS THE COPYRIGHT OF SX-ARCHITECTURAL SERVICES AND MUST NOT BE COPIED OR REPRODUCED, IN WHOLE OR IN PART, BY ANY METHOD WHATSOEVER, WITHOUT THE PRIOR WRITTEN APPROVAL OF SX-ARCHITECTURAL.

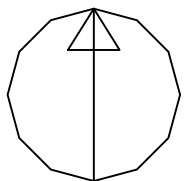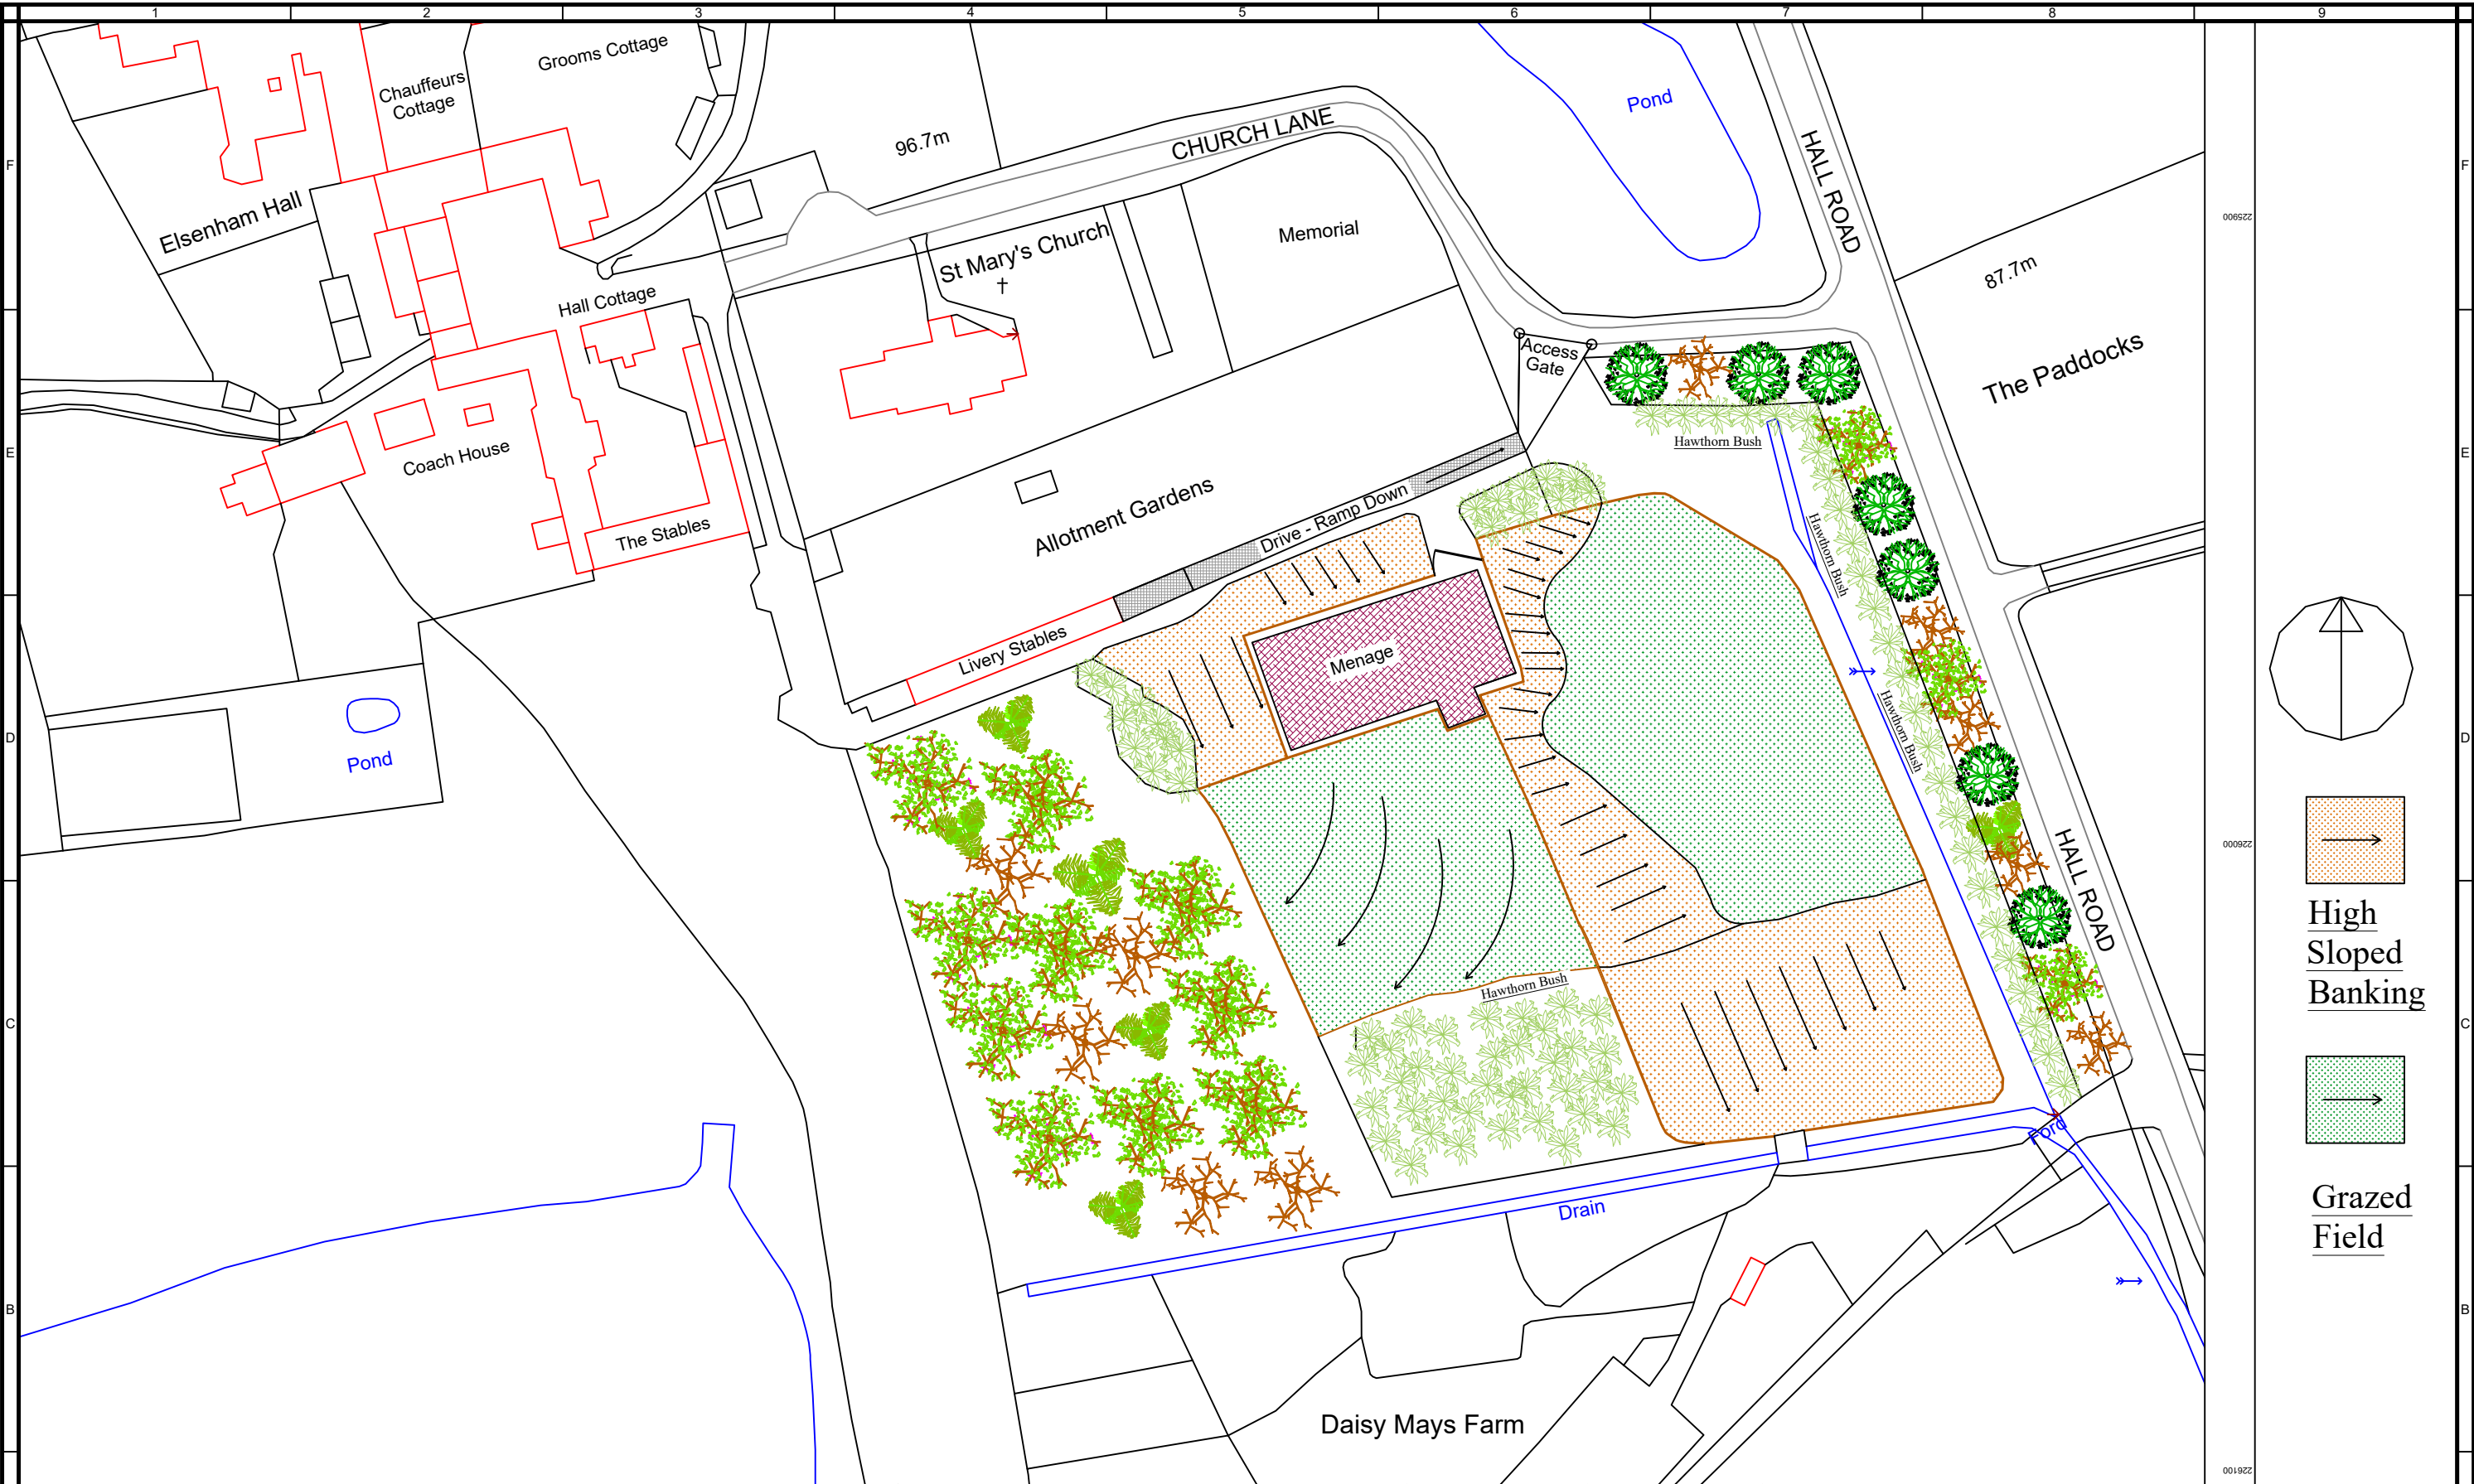


High
Sloped
Banking

 

Grazed
Field


EXISTING PLANS

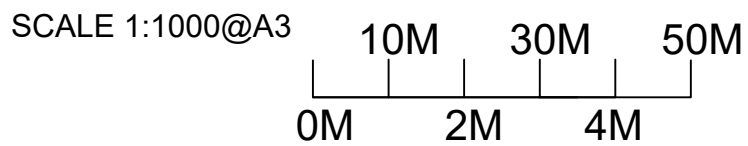

REV	DATE	REVISIONS
A		
B		
C		
D		
E		
F		
G		


Drawing Title	Description	Project Address
Existing Site Area Plan (Pre - Earthwork Infill)	Earthwork Land Build Up & Land Drainage	The Stables Elsenham

INF	DETAILS	CONTRACTOR
Scale	1:1000@A3	
Drawn By	TDH	
Checked By B/I		
Checked By Client	~	
Date		
Drawing Number	ExistSitePln01	
enquiries@sxarchitecture.co.uk		
THIS DRAWING IS THE COPYRIGHT OF SX-ARCHITECTURAL SERVICES AND MUST NOT BE COPIED OR REPRODUCED, IN WHOLE OR IN PART, BY ANY METHOD WHATSOEVER, WITHOUT THE PRIOR WRITTEN APPROVAL OF SX-ARCHITECTURAL.		

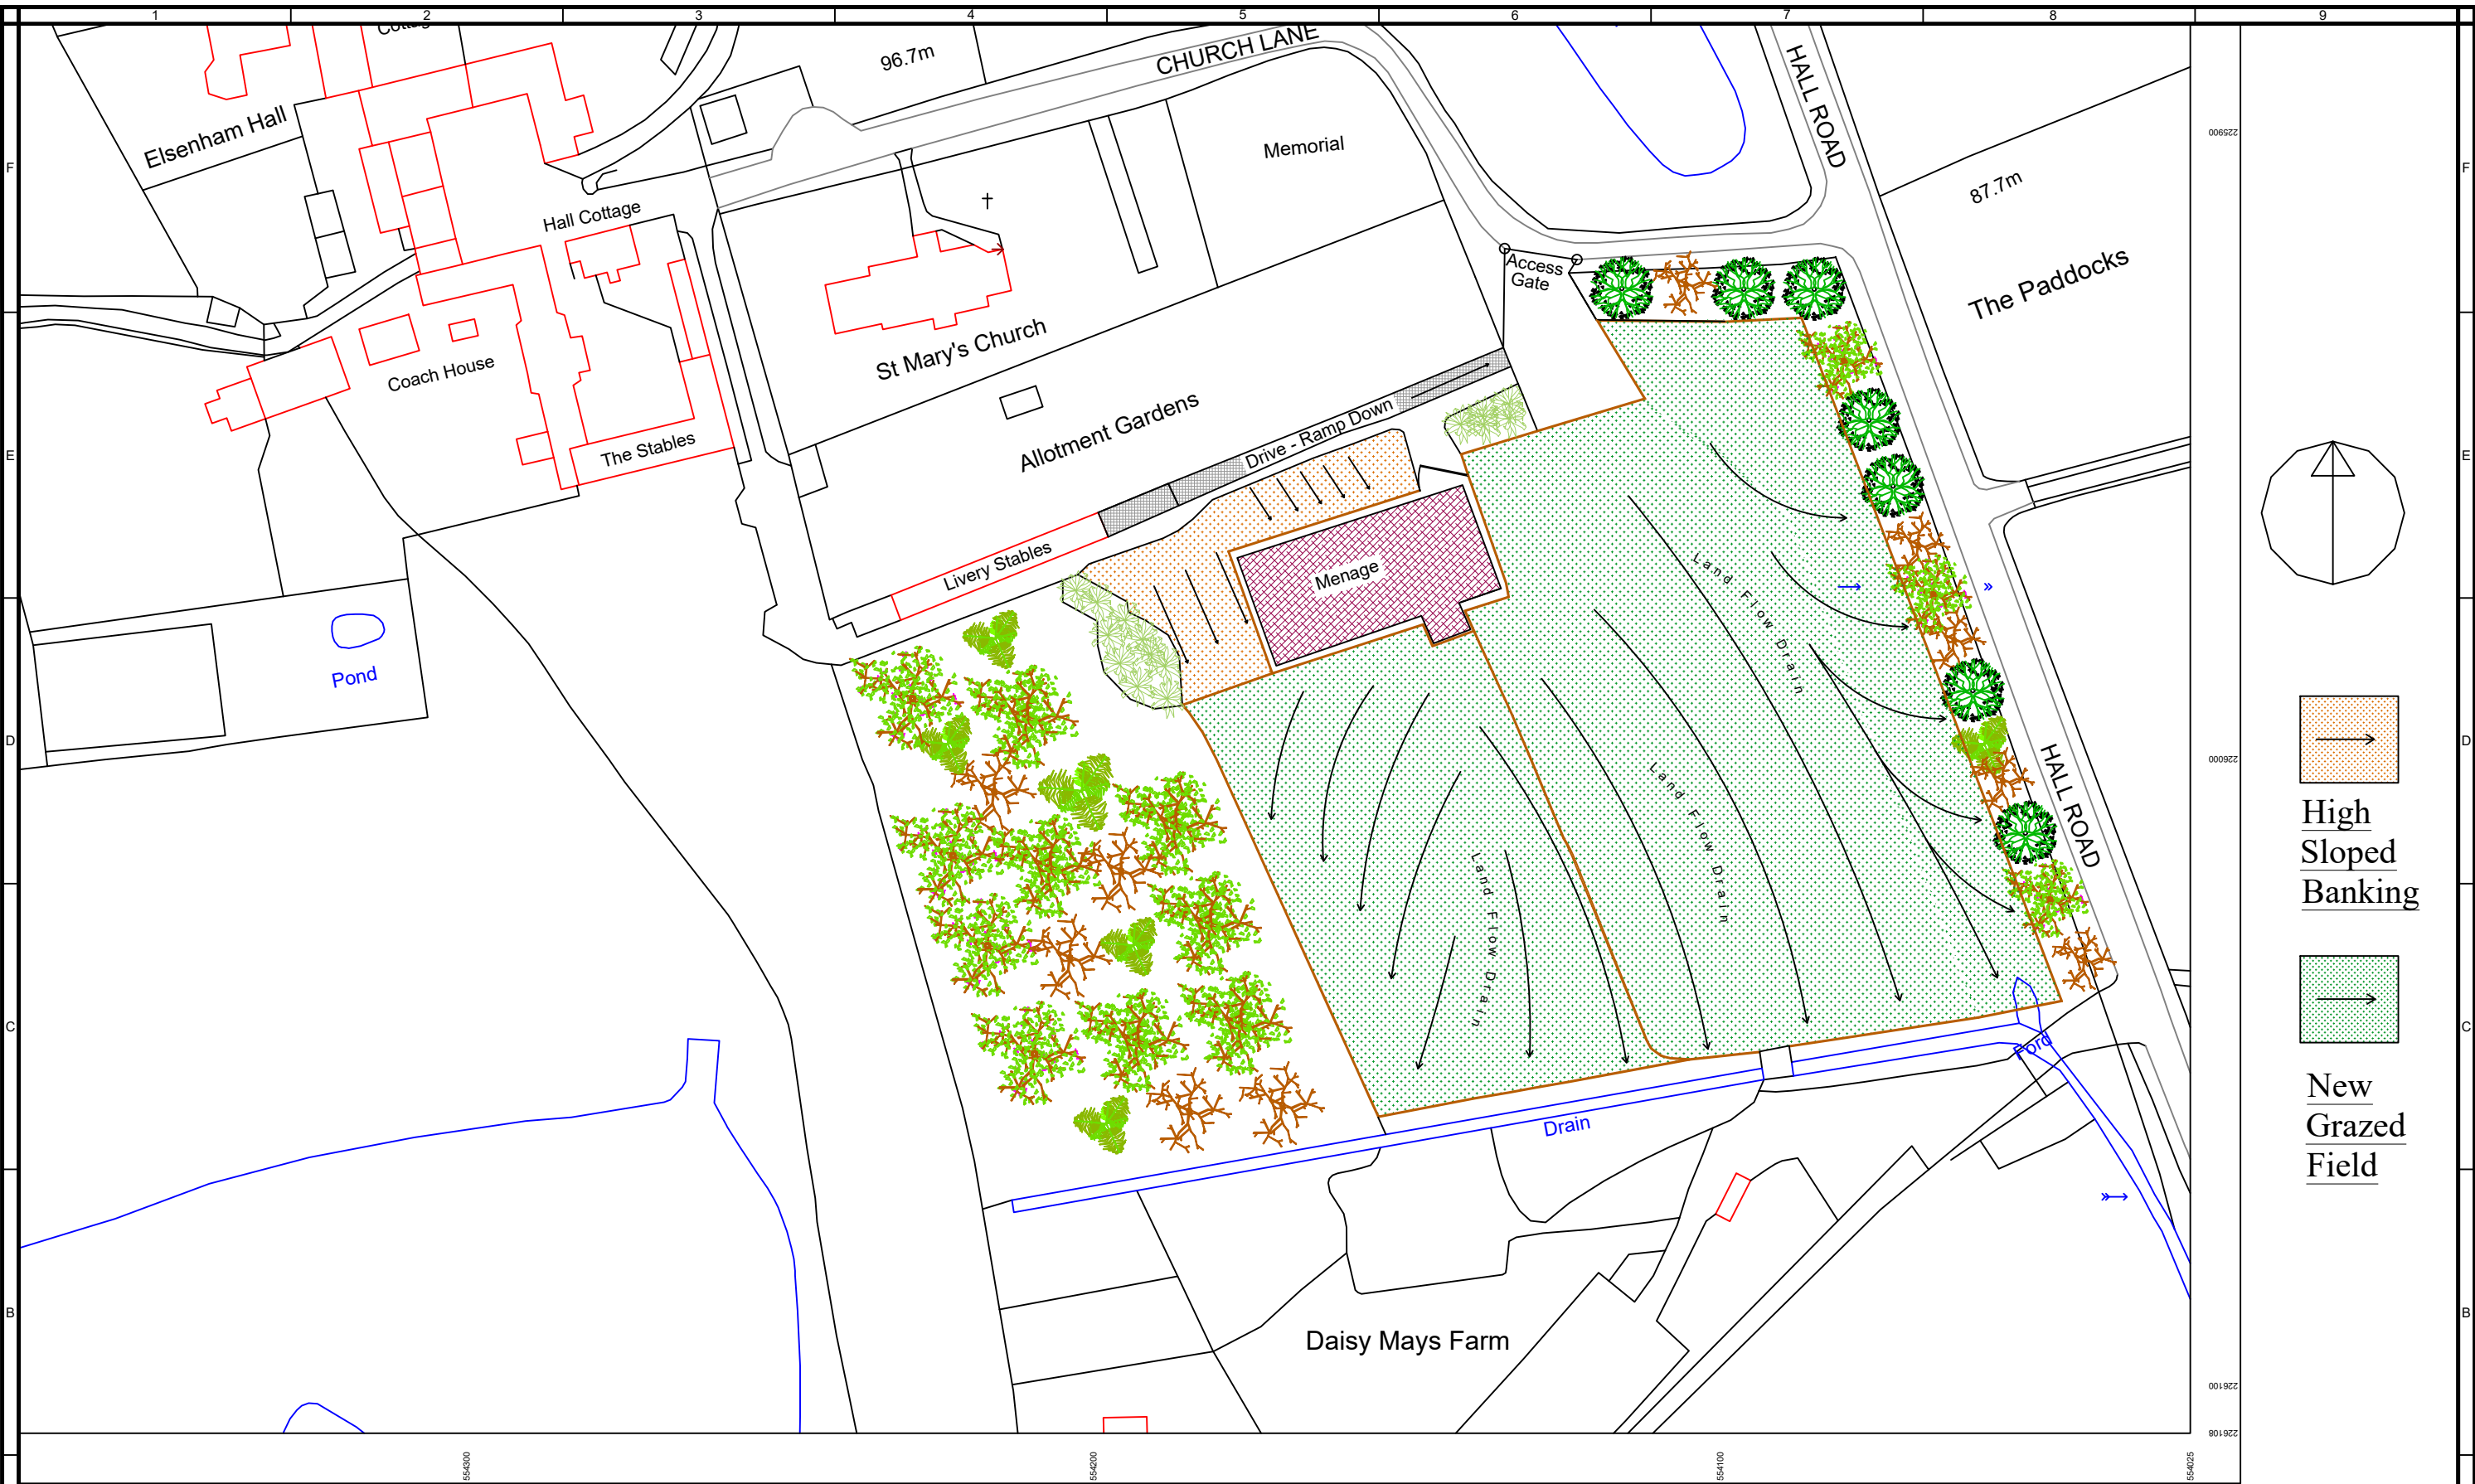

PROPOSED PLANS

SCALE 1:1000@A3

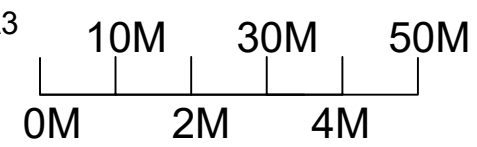



REV	DATE	REVISIONS
A		
B		
C		
D		
E		
F		
G		

Drawing Title	Description	Project Address	INF	DETAILS	CONTRACTOR
Proposed Site Area Plan	Earthwork Land Build Up & Land Drainage	The Stables Elsenham	Scale	1:1000@A3	
Area Plan			Drawn By	TDH	
Earthfill To Grazing Fields			Checked By B/I		
			Checked By Client	~	
			Date		
			Drawing Number		
			TheStablesPropSitePin01		



enquiries@sxarchitecture.co.uk


THIS DRAWING IS THE COPYRIGHT OF SX-ARCHITECTURAL SERVICES AND MUST NOT BE COPIED OR REPRODUCED, IN WHOLE OR IN PART, BY ANY METHOD WHATSOEVER, WITHOUT THE PRIOR WRITTEN APPROVAL OF SX-ARCHITECTURAL.

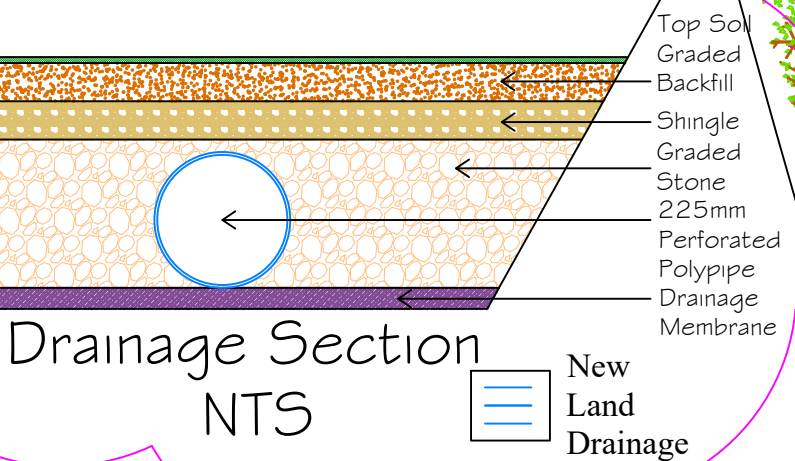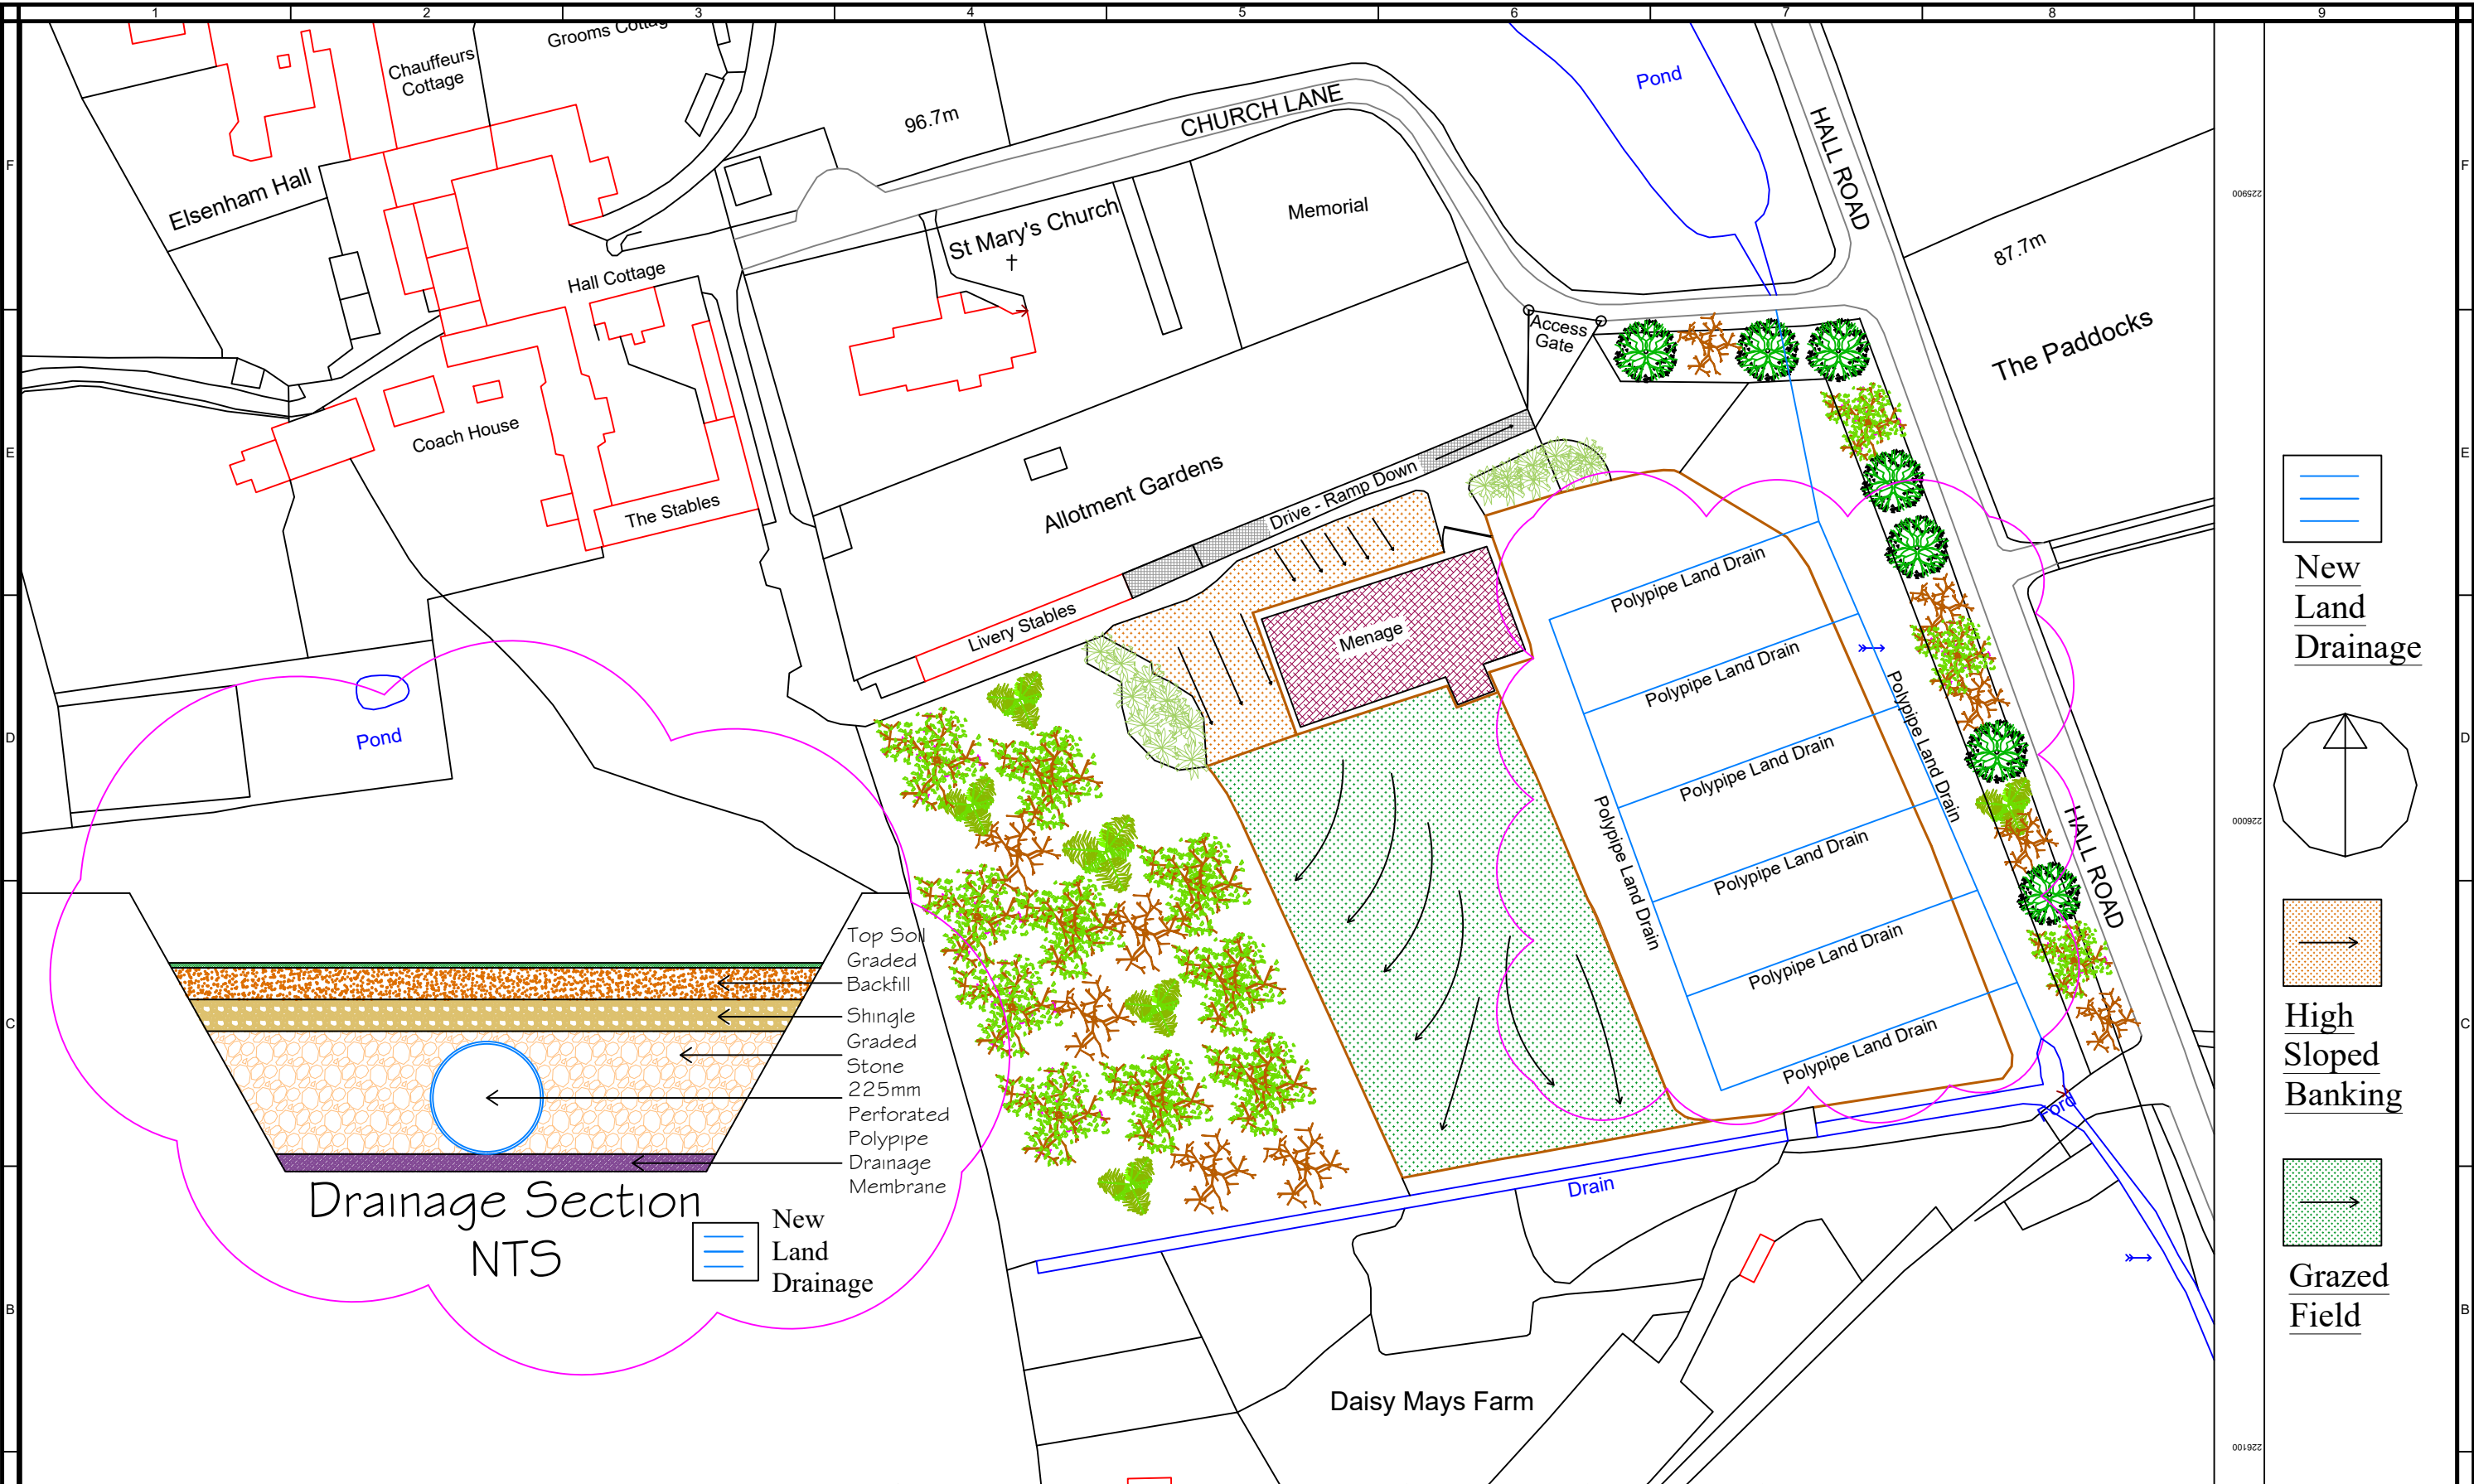


New Land Drainage

High Sloped Banking


Grazed Field

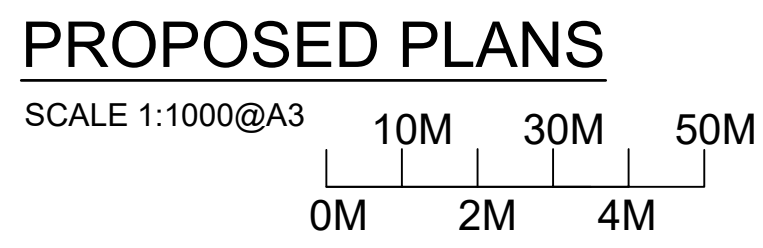

REV			DATE	REVISIONS	Drawing Title	Description	Project Address	INF	DETAILS	CONTRACTOR
A					Land Drain Layout Plan	Drain Build Up & Land Drainage	The Stables Elsenham	Scale	1:1000@A3	SX ARCHITECTURE enquiries@sxarchitecture.co.uk THIS DRAWING IS THE COPYRIGHT OF SX-ARCHITECTURAL SERVICES AND MUST NOT BE COPIED OR REPRODUCED, IN WHOLE OR IN PART, BY ANY METHOD WHATSOEVER, WITHOUT THE PRIOR WRITTEN APPROVAL OF SX-ARCHITECTURAL.
B								Drawn By	TDH	
C								Checked By B/I		
D								Checked By Client	~	
E								Date		
F								Drawing Number	TheStables-DrainPln01	
G										

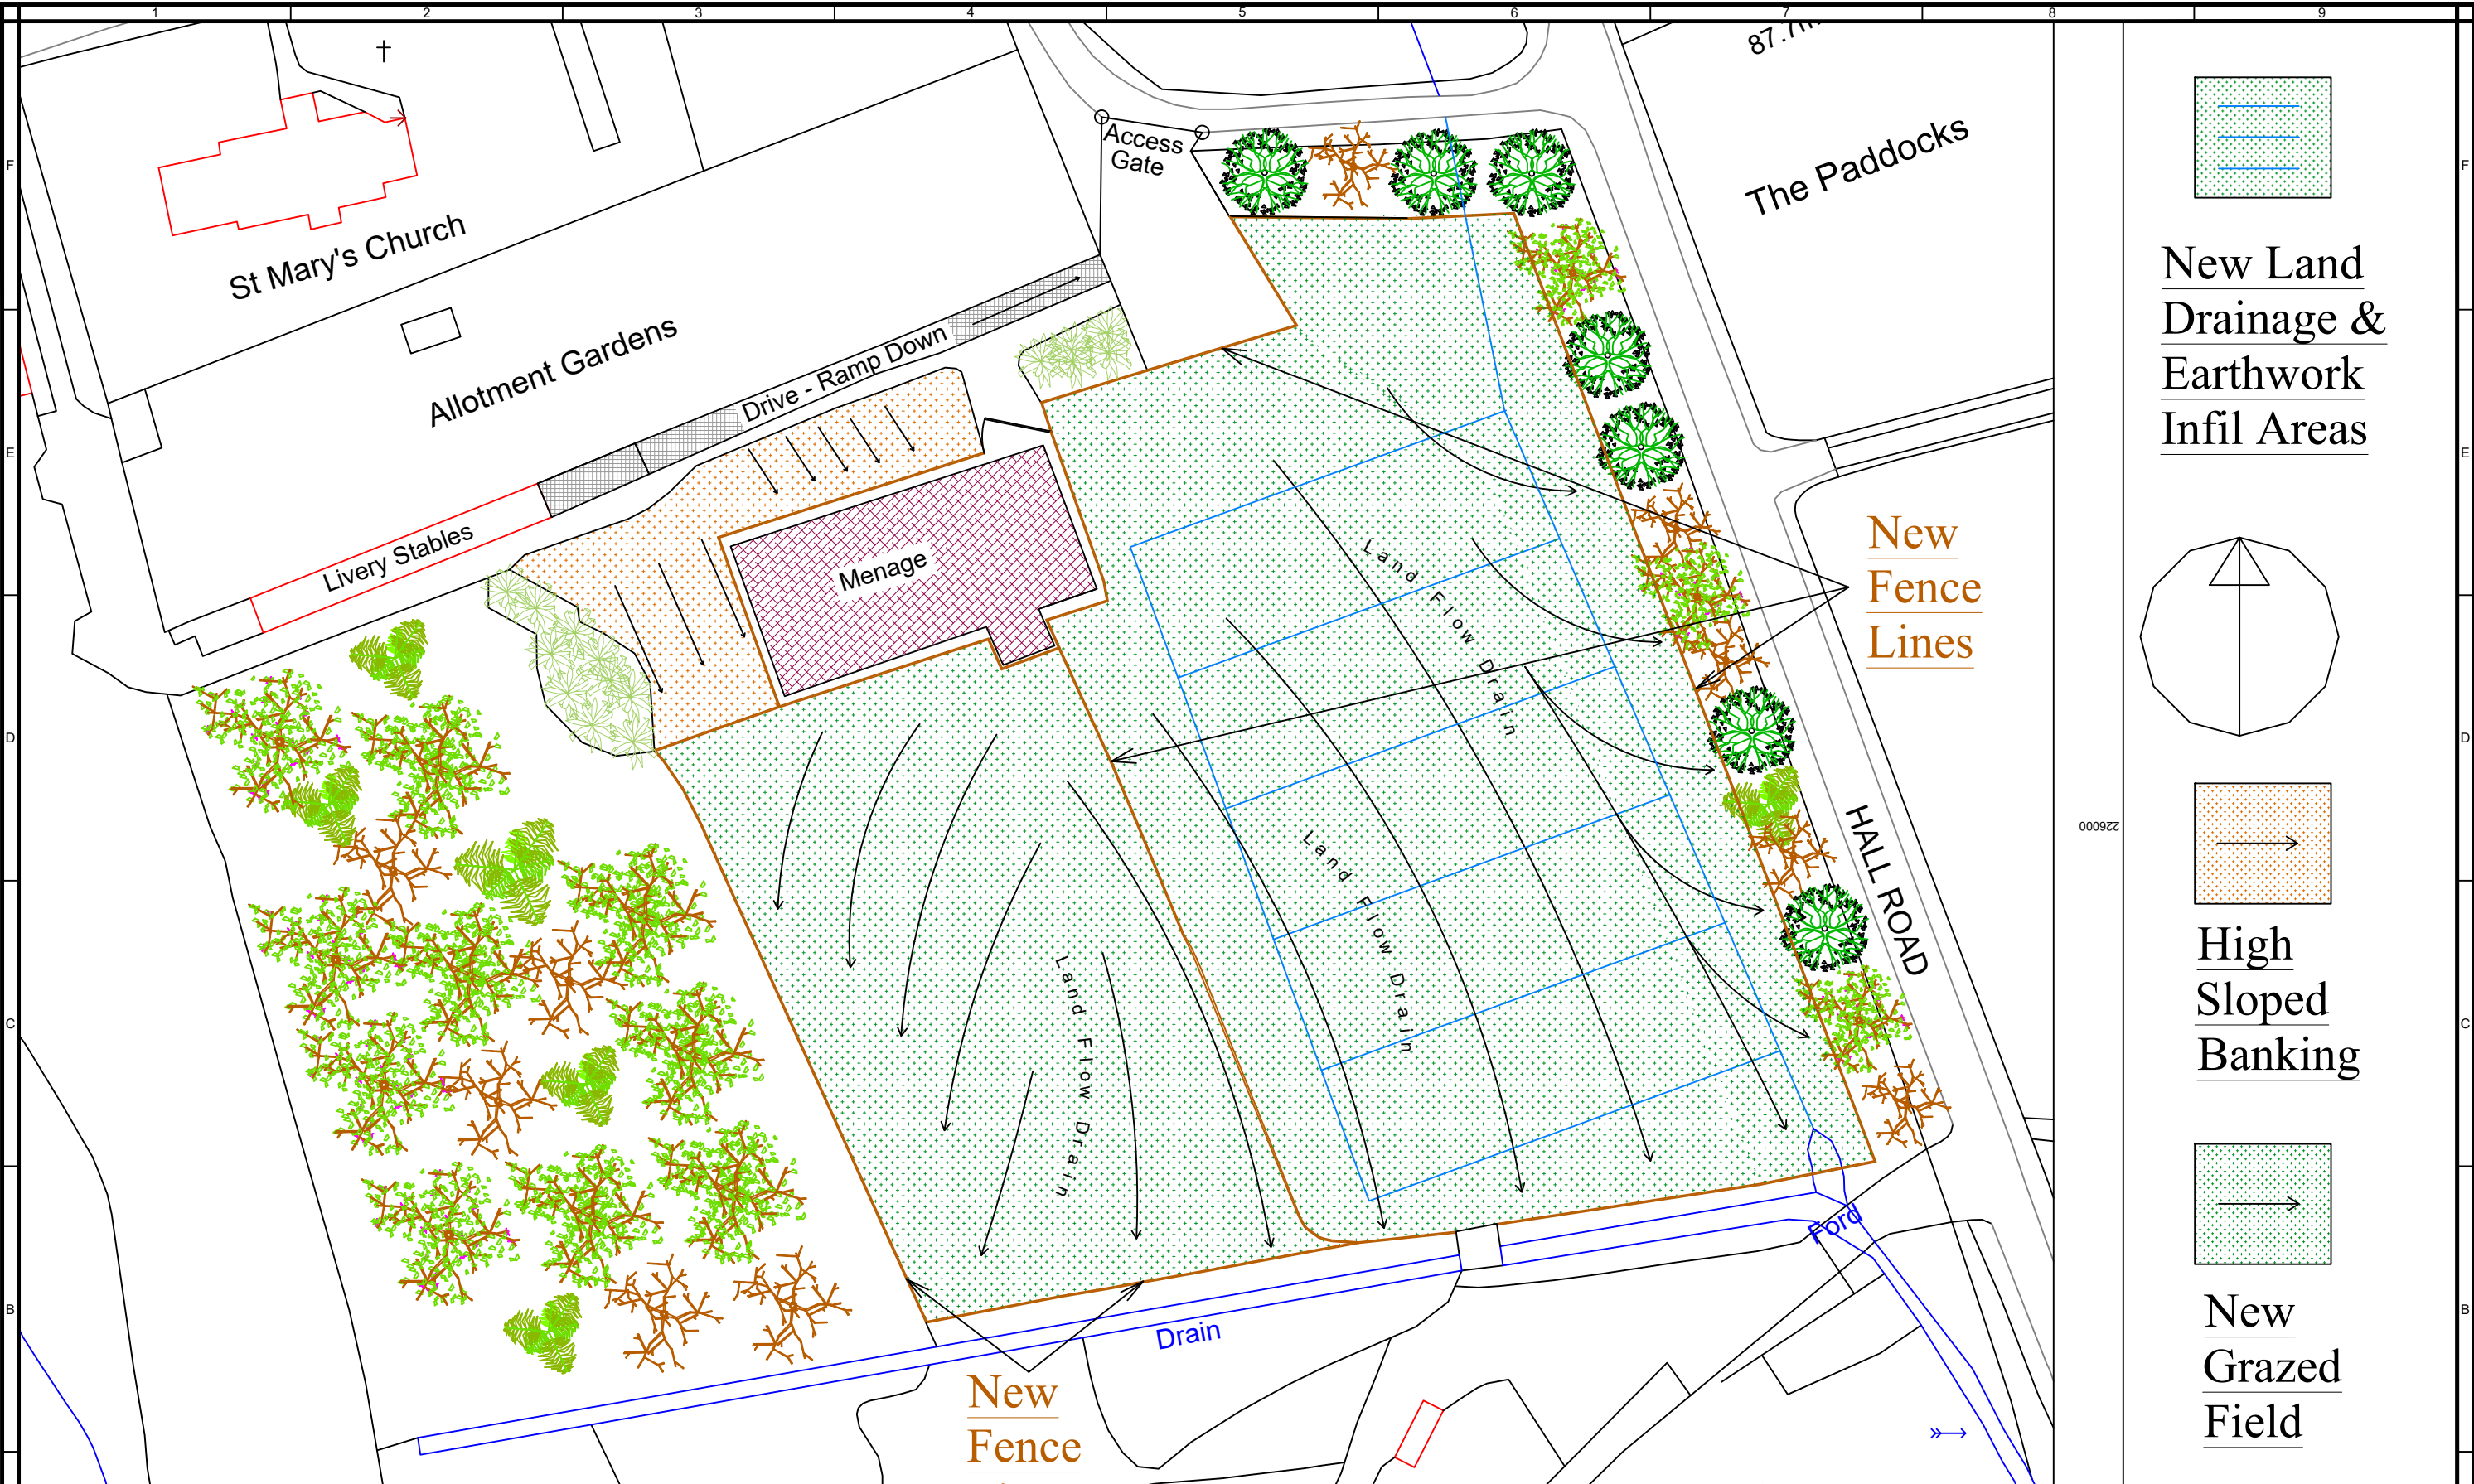

PROPOSED PLANS

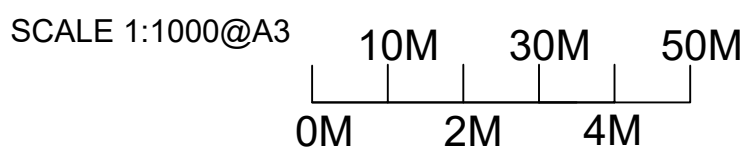

REV	DATE	REVISIONS
A		
B		
C		
D		
E		
F		
G		

Drawing Title	Description	Project Address
Earthfill & Drainage Layout to Grazing Fields	Earthwork Land Build Up & Land Drainage	The Stables Elsenham


INF	DETAILS
Scale	NTS
Drawn By	TDH
Checked By B/I	
Checked By Client	~
Date	
Drawing Number TheStablesDrainPln02	

CONTRACTOR

enquiries@sxarchitecture.co.uk


THIS DRAWING IS THE COPYRIGHT OF SX-ARCHITECTURAL SERVICES AND MUST NOT BE COPIED OR REPRODUCED, IN WHOLE OR IN PART, BY ANY METHOD WHATSOEVER, WITHOUT THE PRIOR WRITTEN APPROVAL OF SX-ARCHITECTURAL.

- New Land Drainage & Earthwork Infil Areas
-
- High Sloped Banking
- New Grazed Field

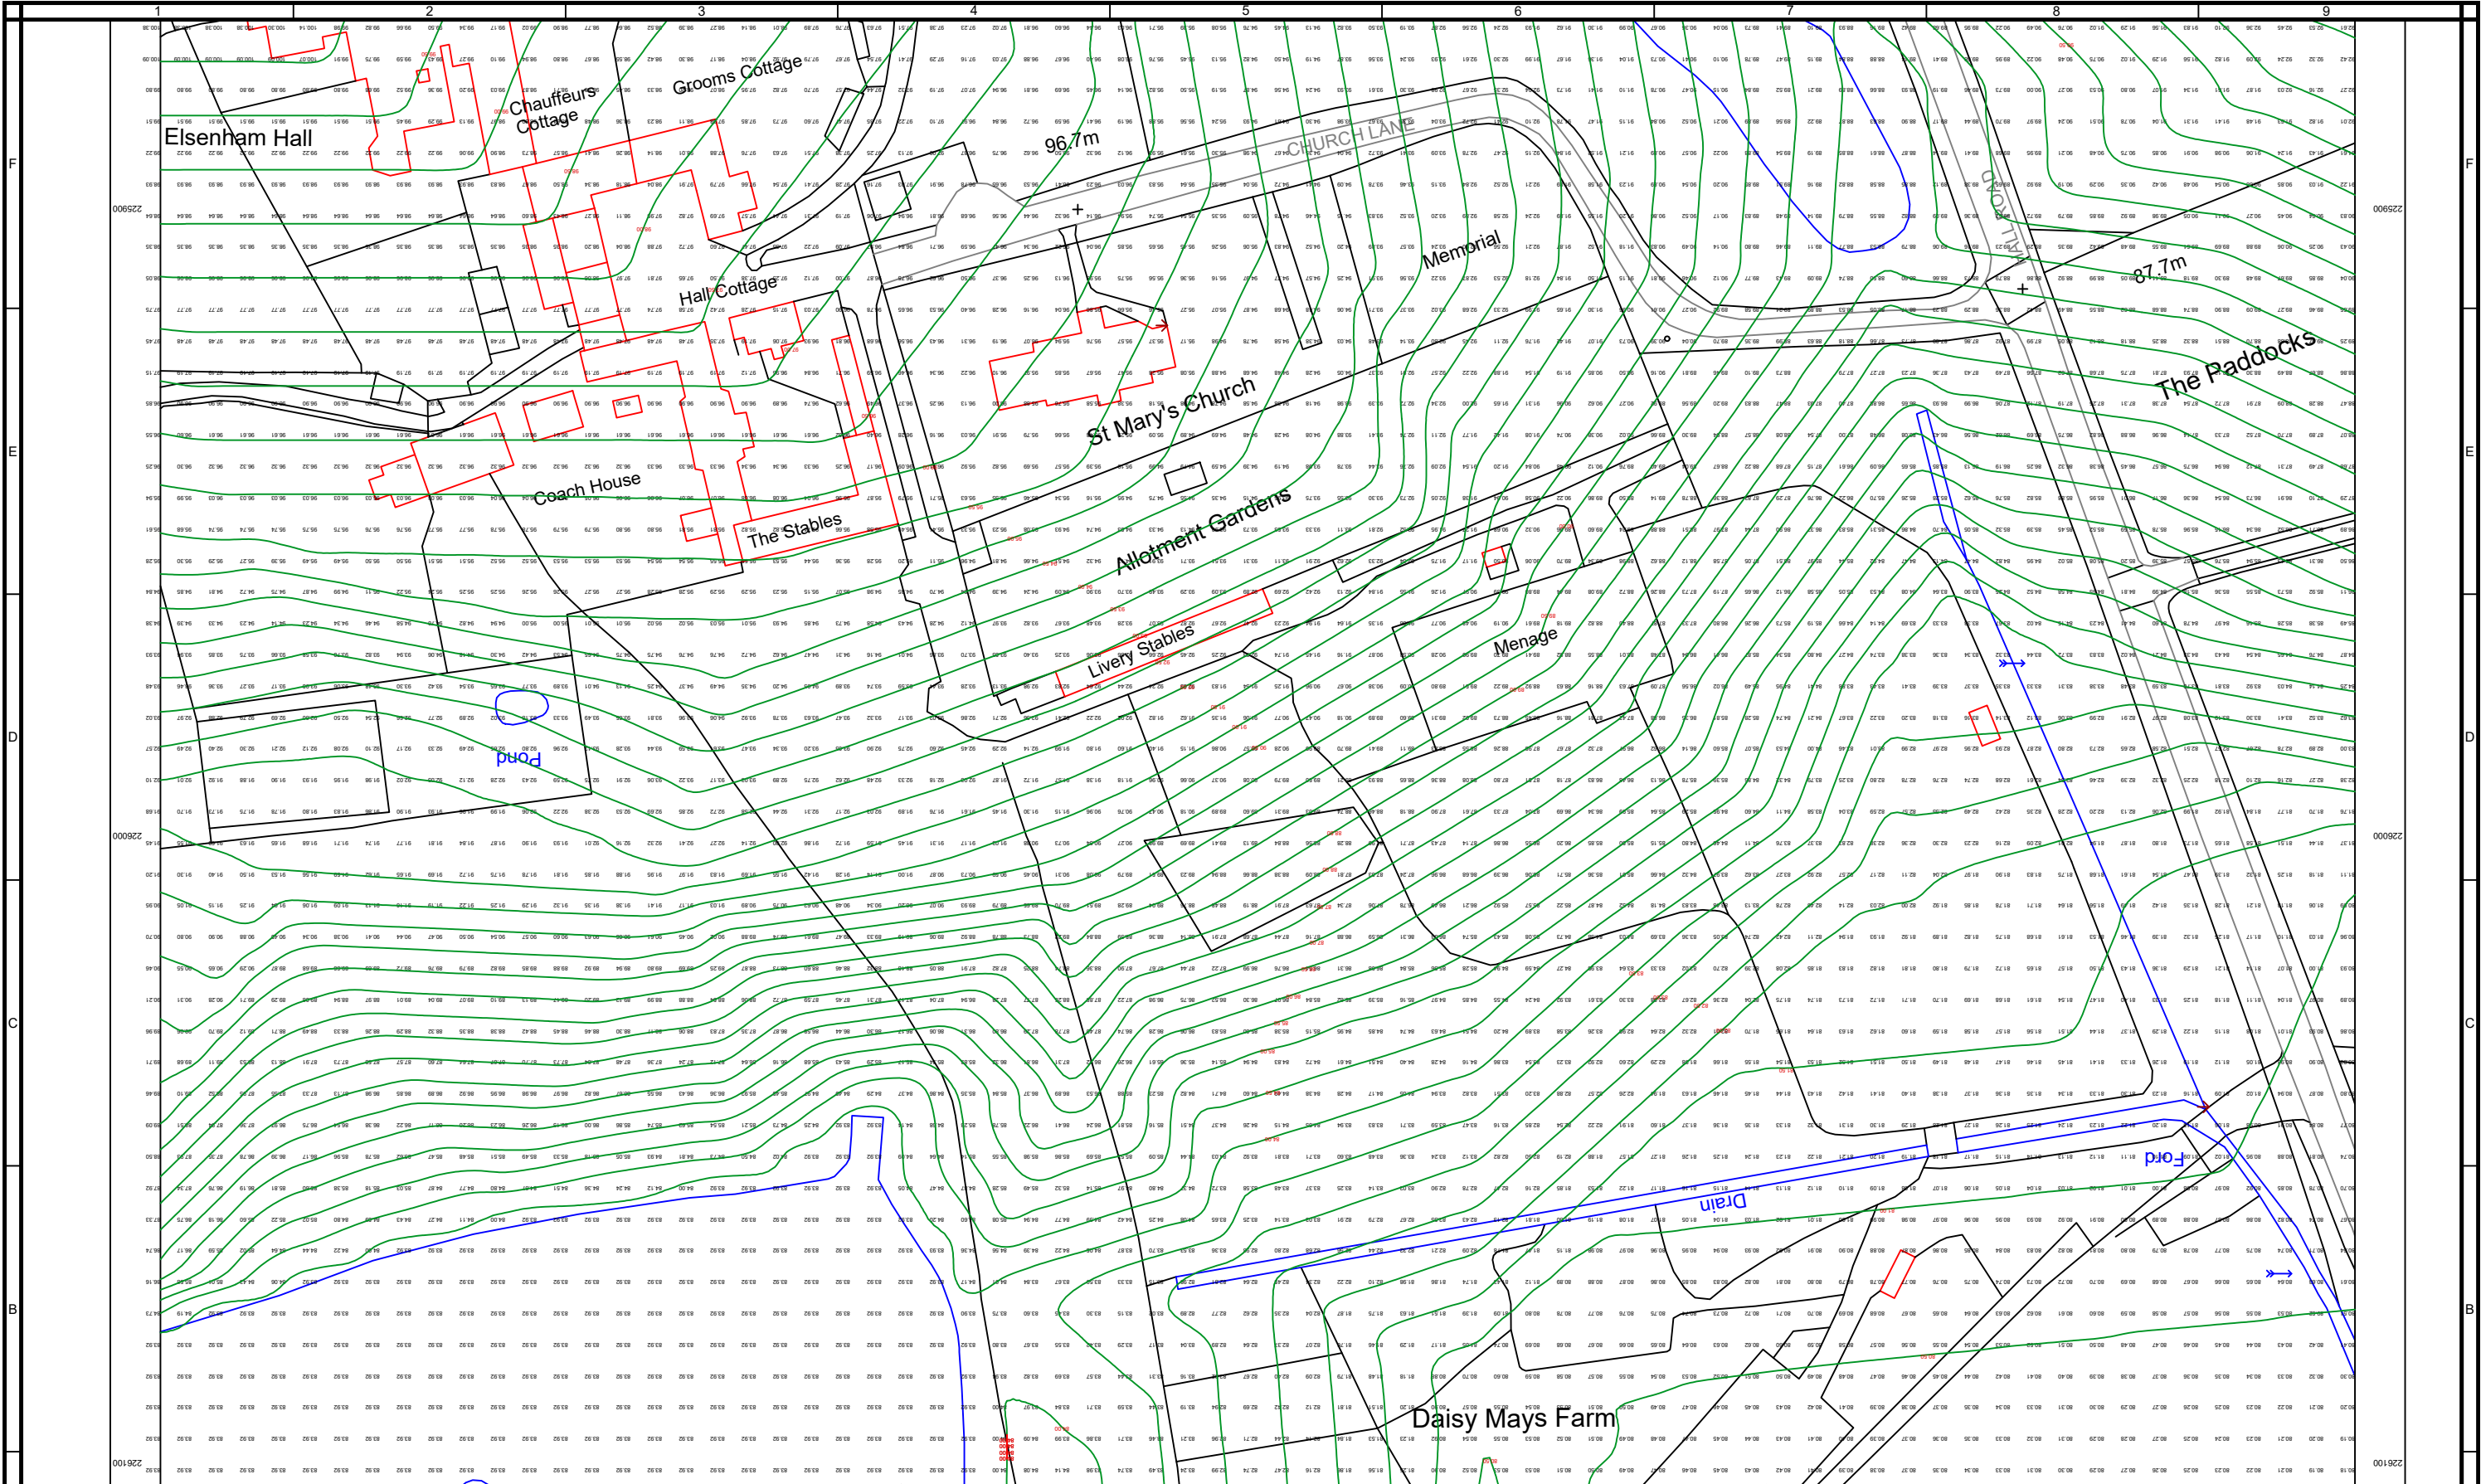


EXISTING TOPOLOGY SITE PLAN

SCALE 1:1000@A3

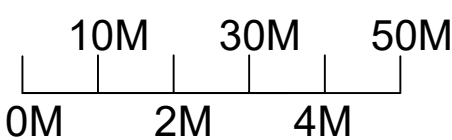


REV	DATE	REVISIONS
A		
B		
C		
D		
E		
F		
G		

Drawing Title	Description	Project Address	INF	DETAILS	CONTRACTOR
Existing Site Topology Plan	Earthwork Land Build Up & Land Drainage	The Stables Elsenham	Scale 1:1000@A3	TDH	 enquiries@sxarchitecture.co.uk
			Drawn By		
			Checked By B/I		
			Checked By Client		
			Date		
			Drawing Number	ExistTopologySitePlan-01	THIS DRAWING IS THE COPYRIGHT OF SX-ARCHITECTURAL SERVICES AND MUST NOT BE COPIED OR REPRODUCED, IN WHOLE OR IN PART, BY ANY METHOD WHATSOEVER, WITHOUT THE PRIOR WRITTEN APPROVAL OF SX-ARCHITECTURAL.

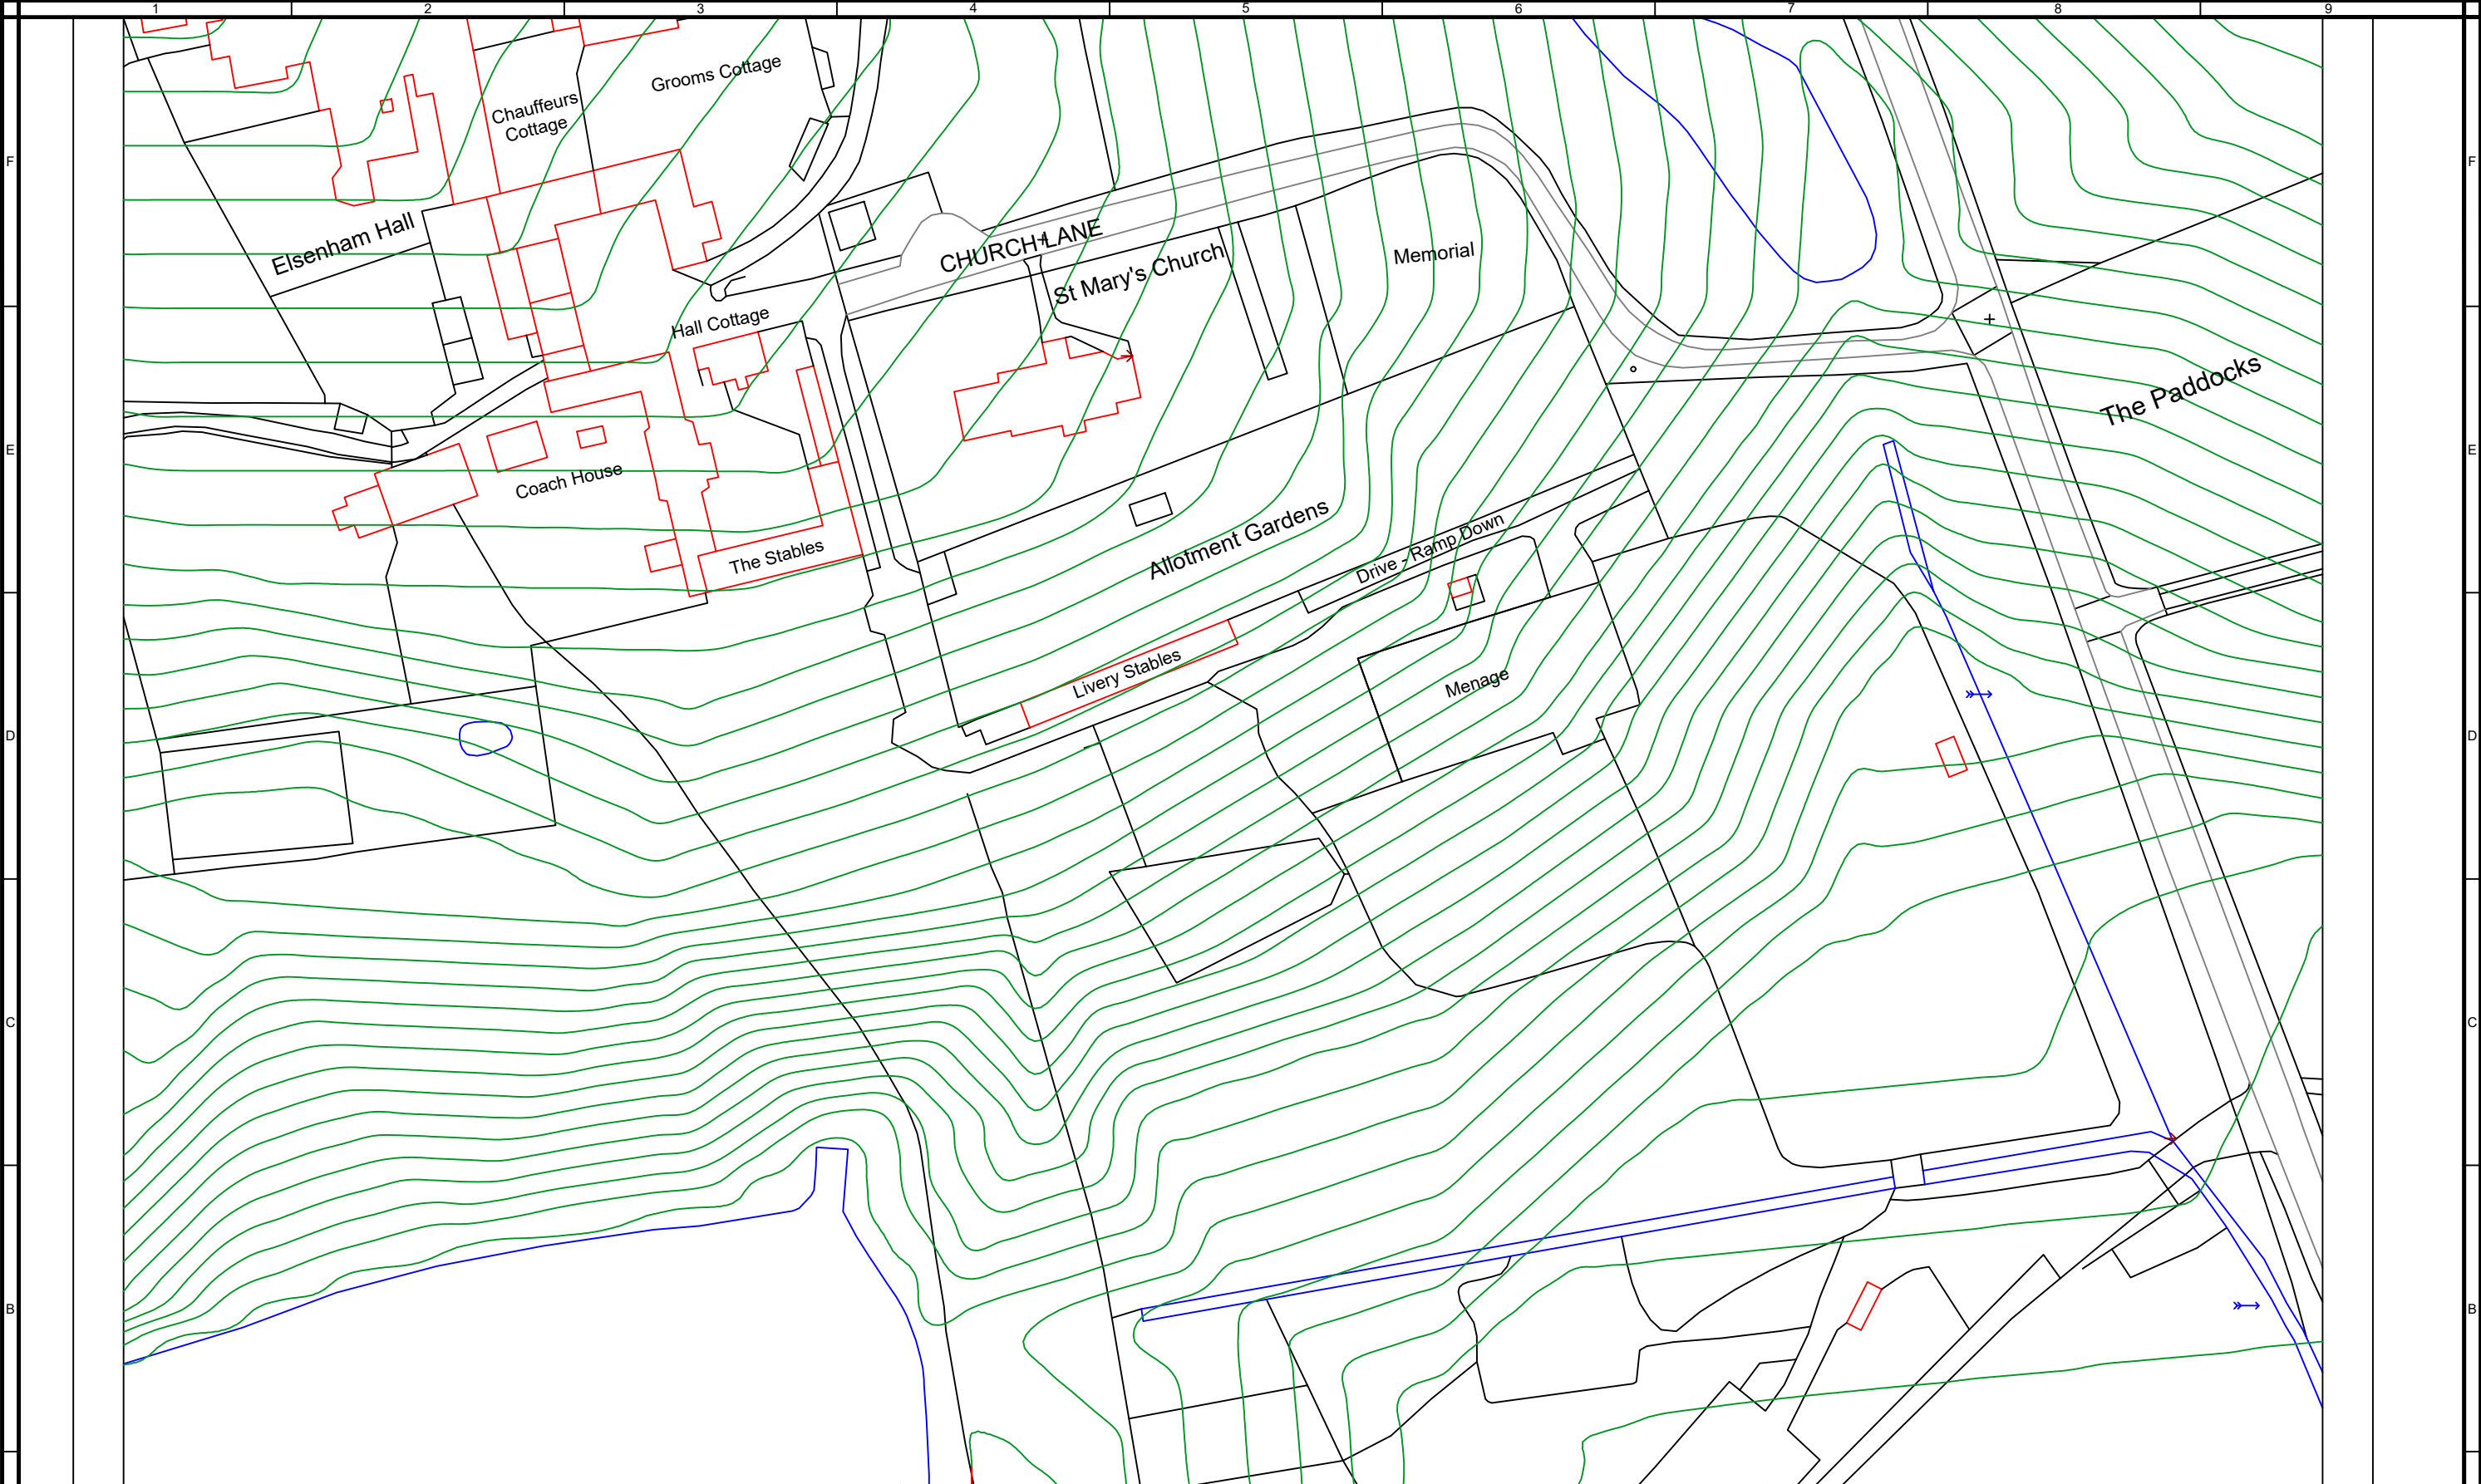

EXISTING TOPOLOGY SITE PLAN

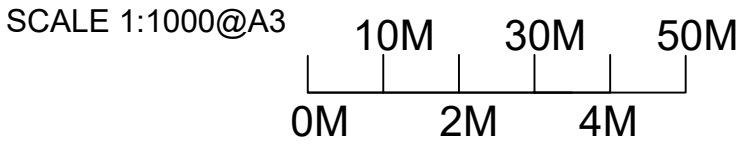

REV	DATE	REVISIONS
A		
B		
C		
D		
E		
F		
G		

Drawing Title	Description	Project Address
Existing Site Topology Plan	Earthwork Land Build Up & Land Drainage	The Stables Elsenham

INF	DETAILS	CONTRACTOR
Scale	1:1000@A3	SX ARCHITECTURE enquiries@sxarchitecture.co.uk THIS DRAWING IS THE COPYRIGHT OF SX-ARCHITECTURAL SERVICES AND MUST NOT BE COPIED OR REPRODUCED, IN WHOLE OR IN PART, BY ANY METHOD WHATSOEVER, WITHOUT THE PRIOR WRITTEN APPROVAL OF SX-ARCHITECTURAL.
Drawn By	TDH	
Checked By B/I		
Checked By Client	~	
Date		
Drawing Number ExistTopologySitePln02		