




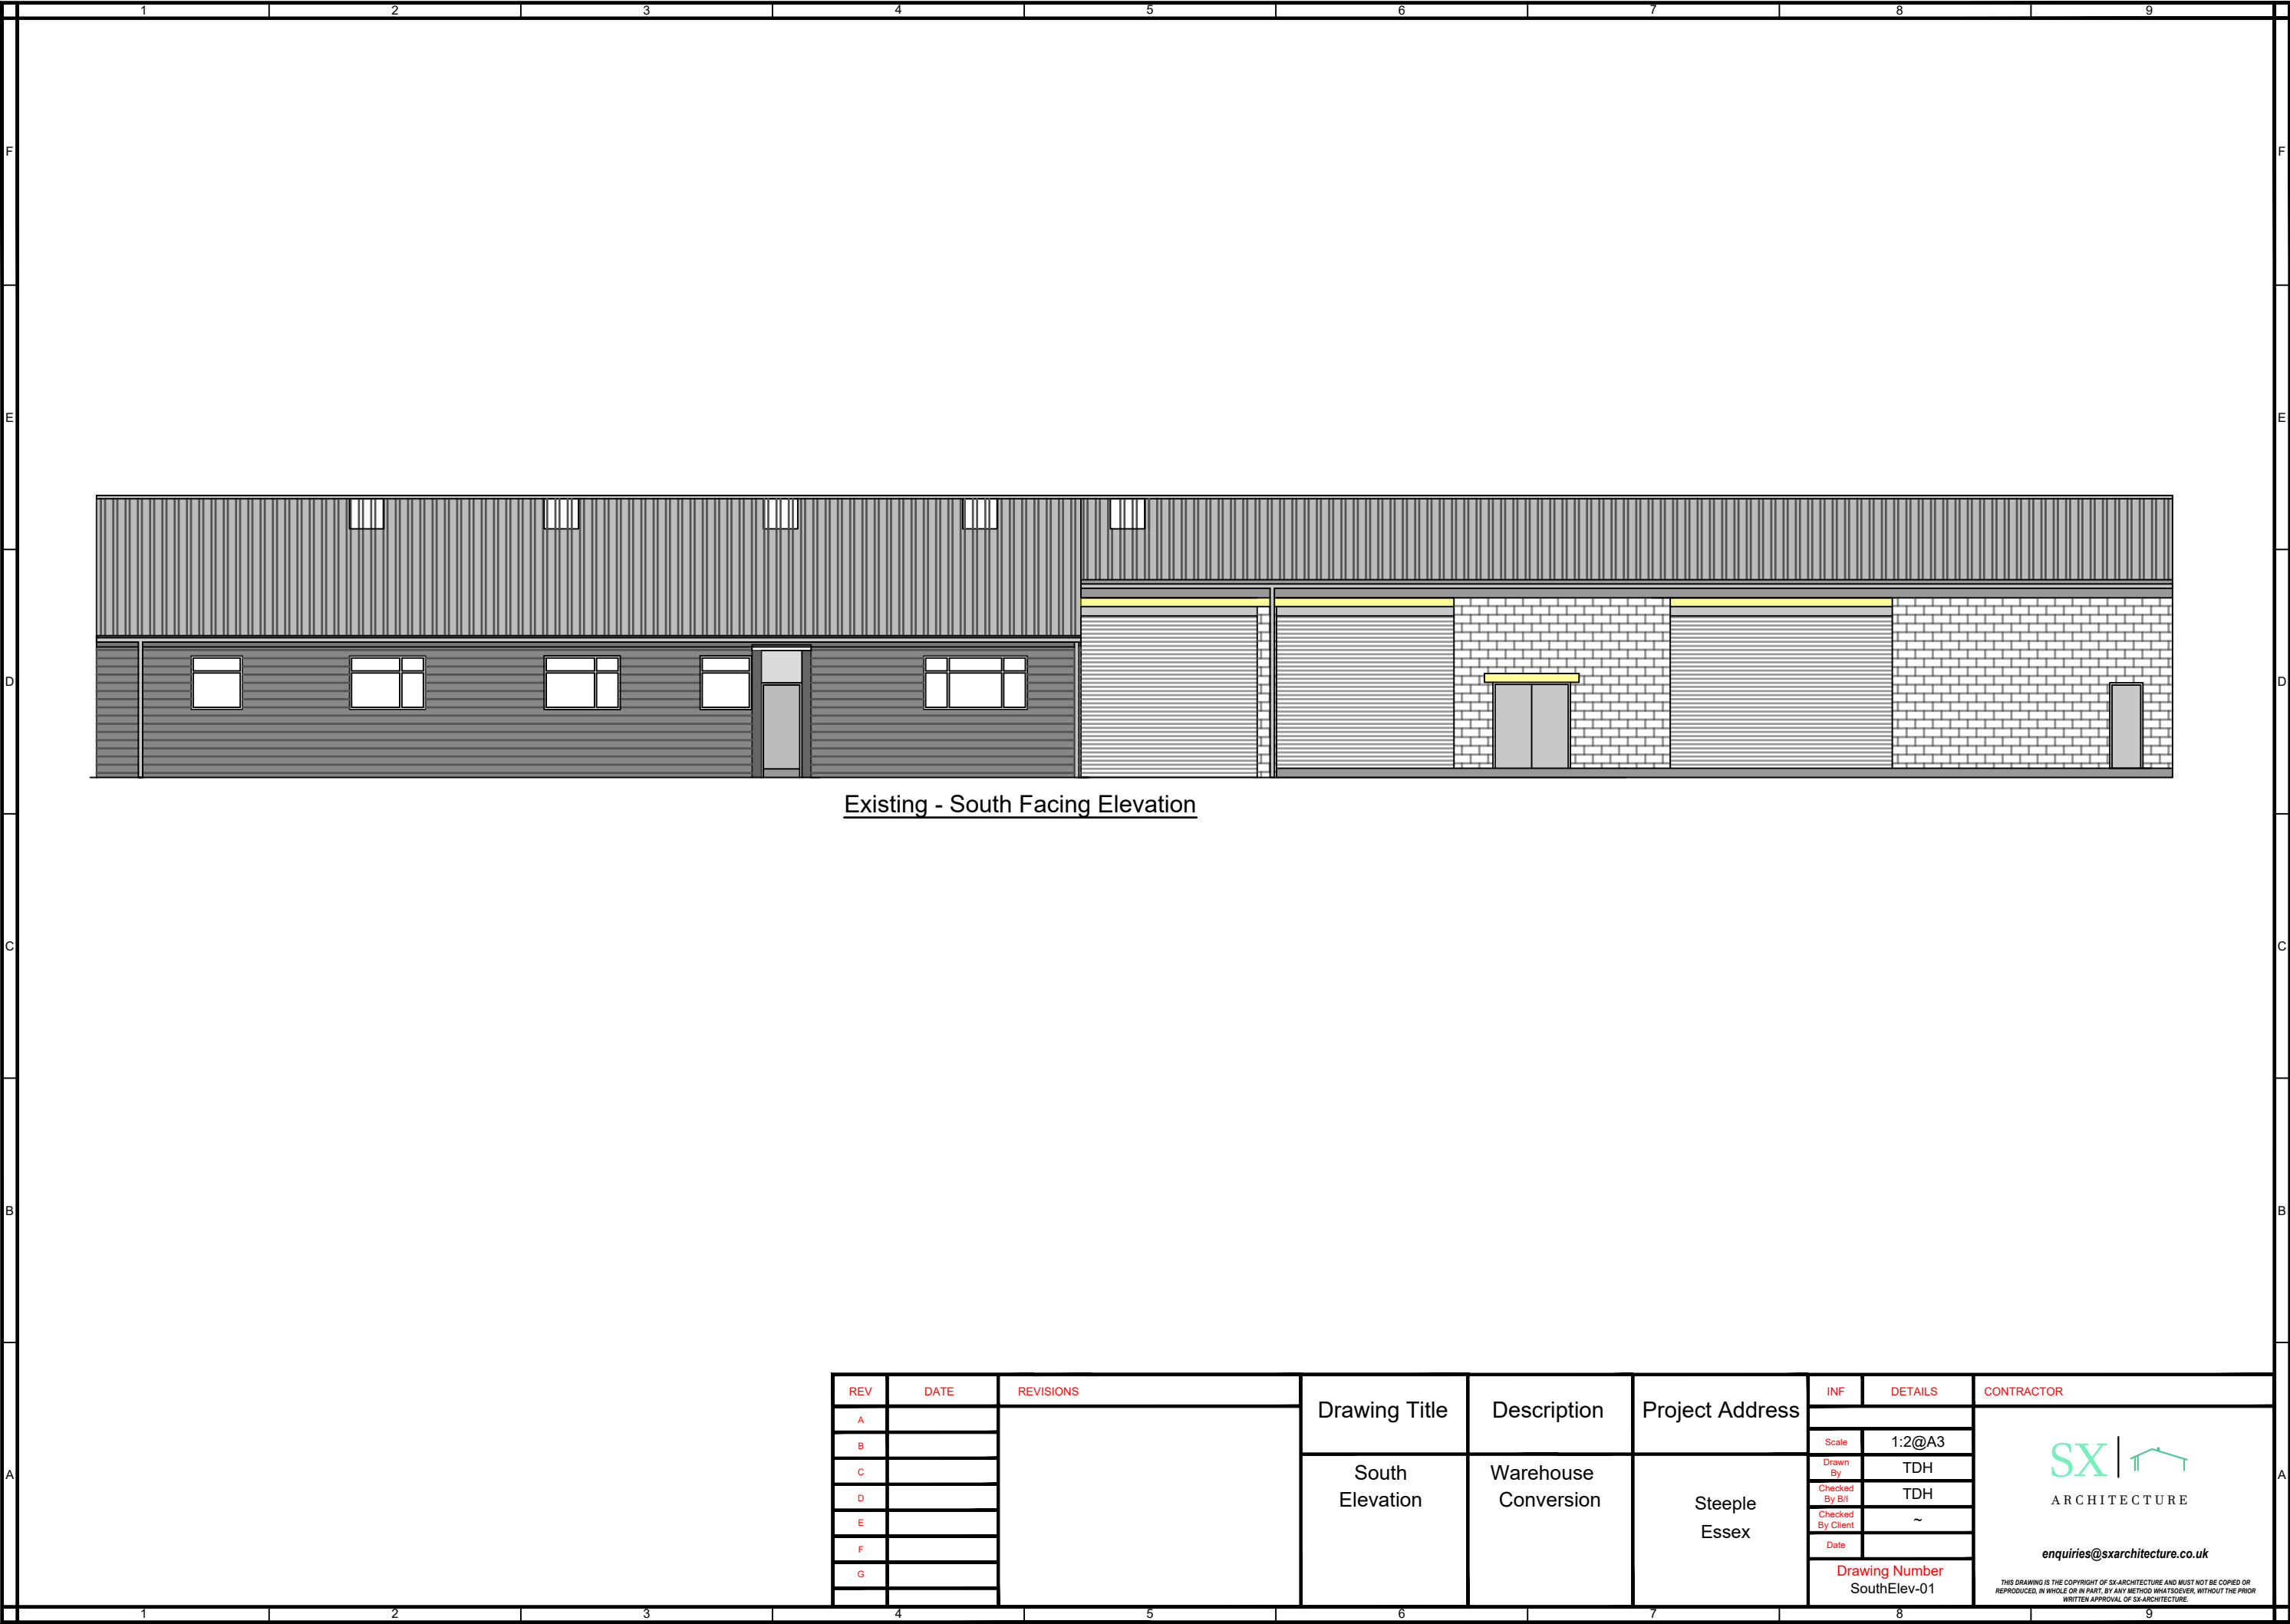

Existing - South Facing Elevation


REV	DATE	REVISIONS	Drawing Title	Description	Project Address	INF	DETAILS	CONTRACTOR
A			South Elevation	Warehouse Conversion	Steeple Essex			SX  ARCHITECTURE enquiries@sxarchitecture.co.uk THIS DRAWING IS THE COPYRIGHT OF SX ARCHITECTURE AND MUST NOT BE COPIED OR REPRODUCED, IN WHOLE OR IN PART, BY ANY METHOD WHATSOEVER, WITHOUT THE PRIOR WRITTEN APPROVAL OF SX ARCHITECTURE.
B						Scale	1:2@A3	
C						Drawn By	TDH	
D						Checked By B/I	TDH	
E						Checked By Client	~	
F						Date		
G						Drawing Number SouthElev-01		

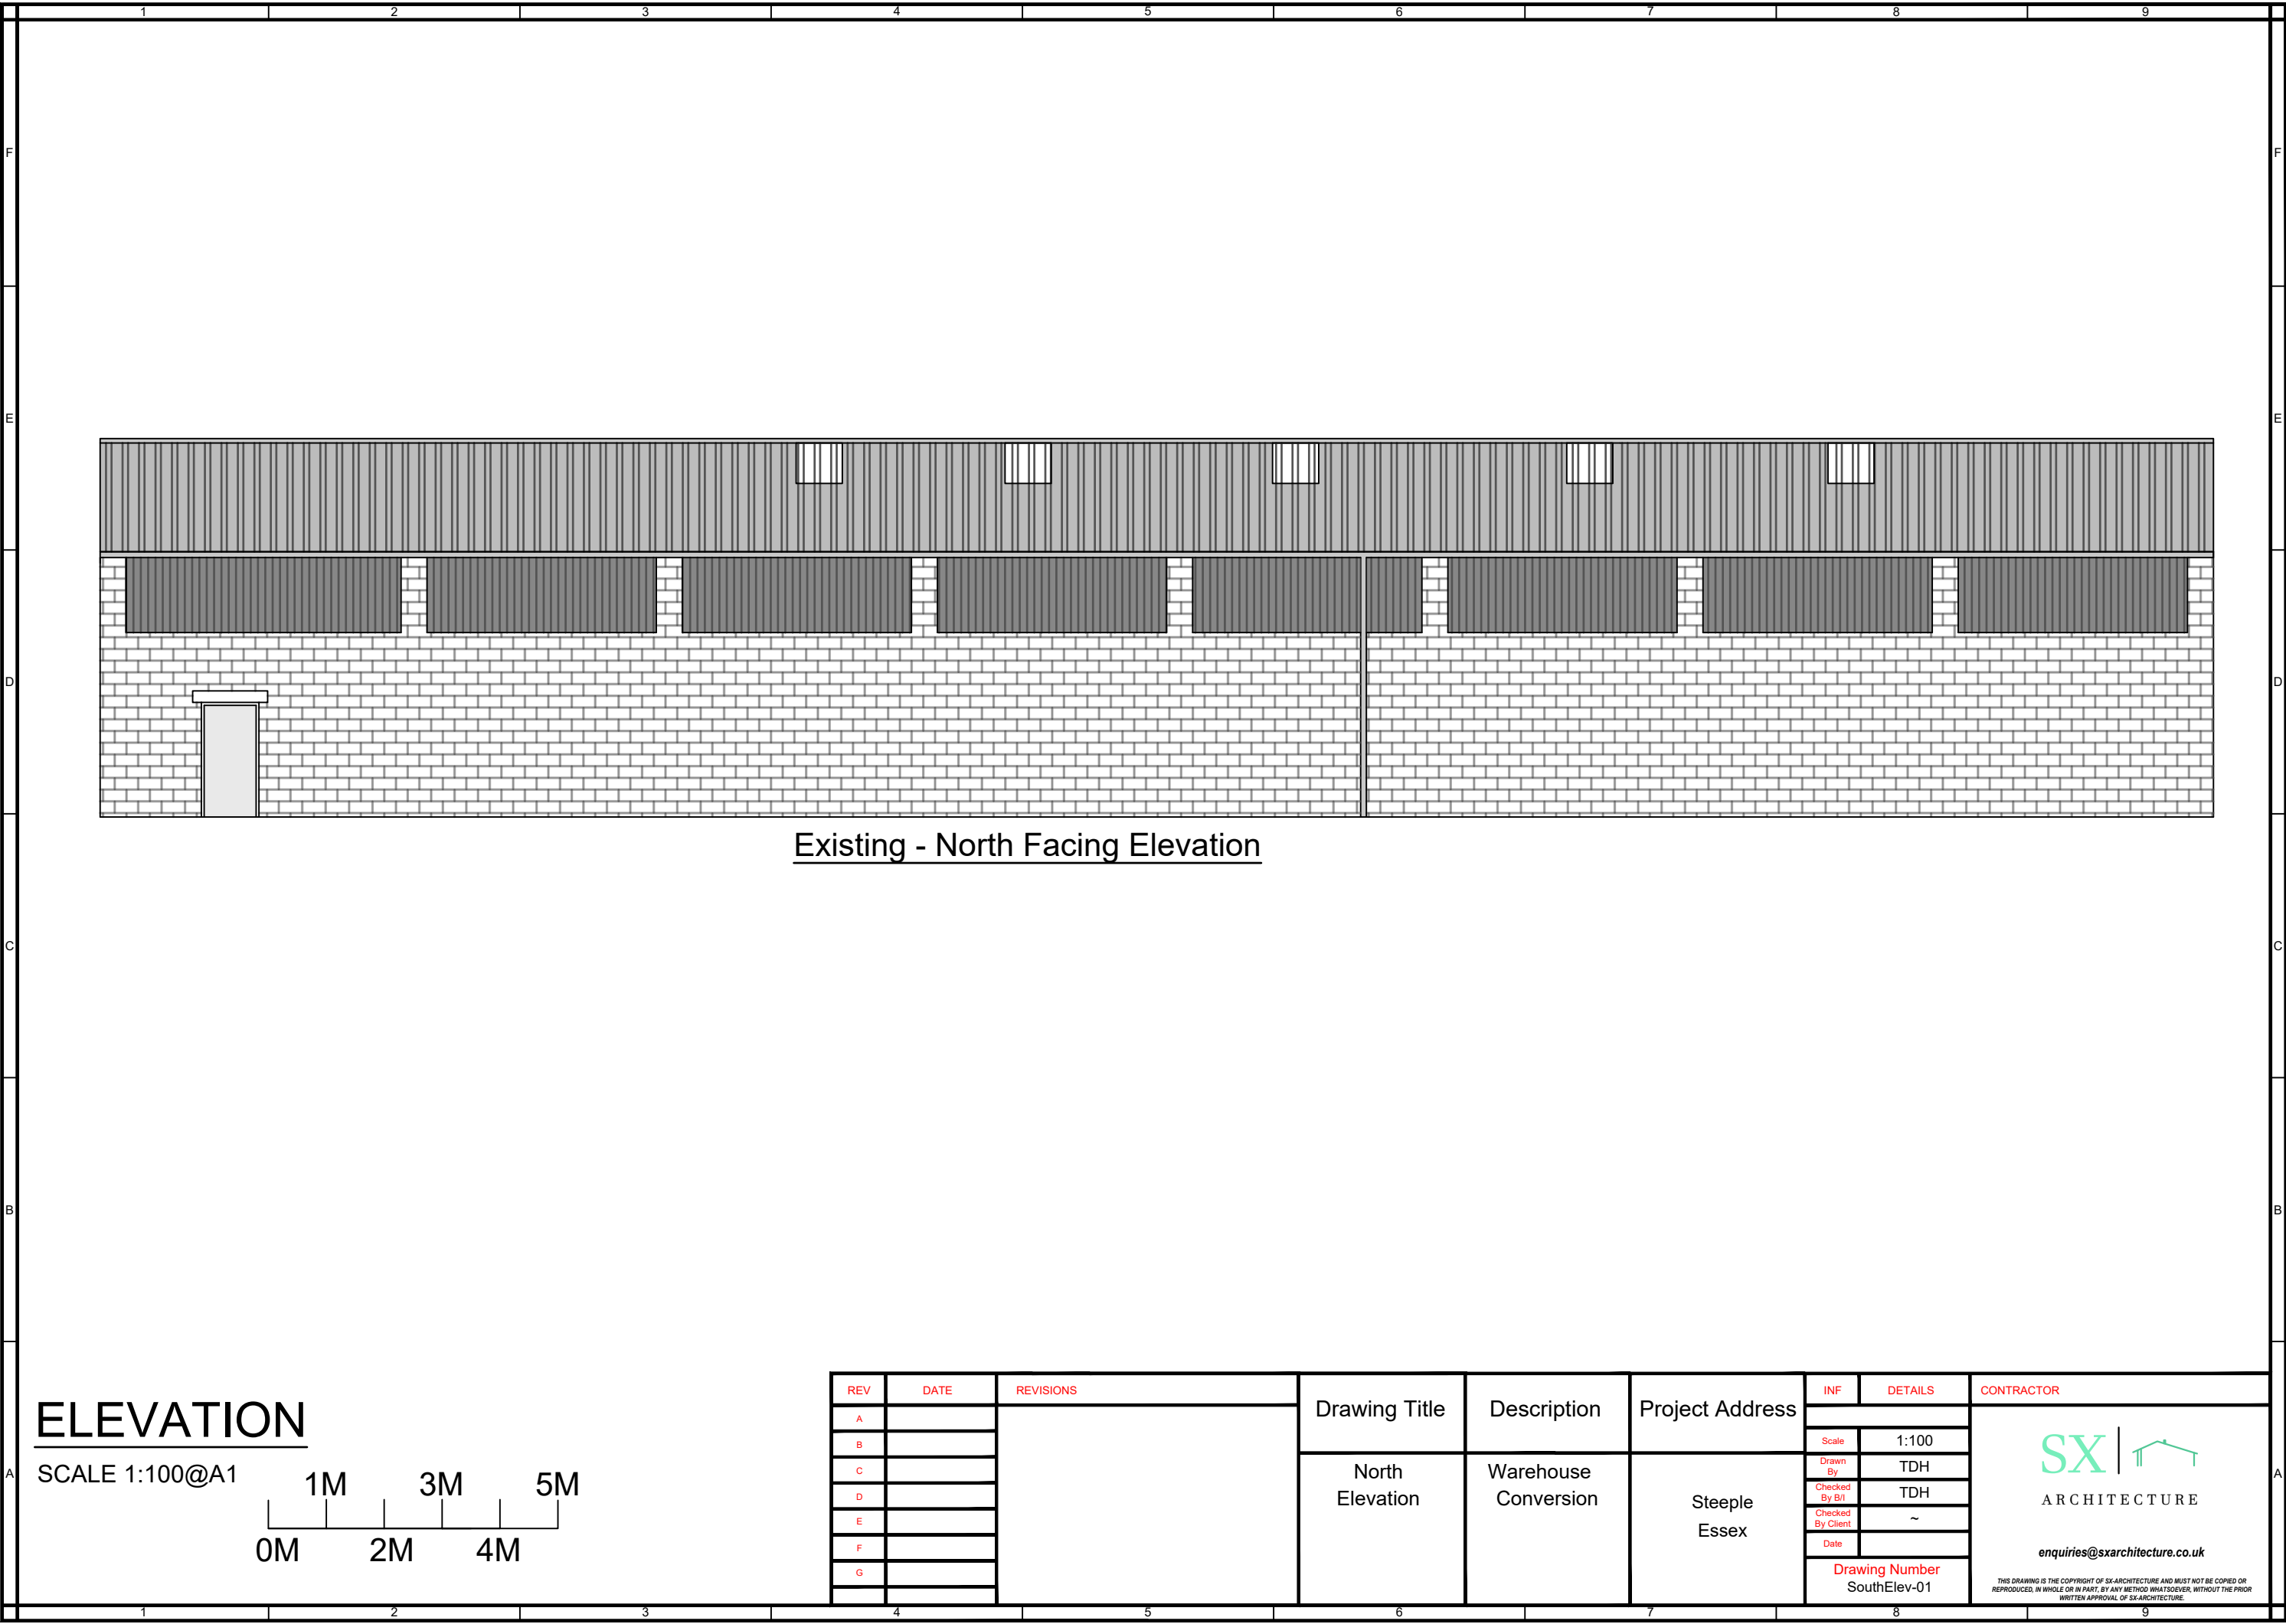

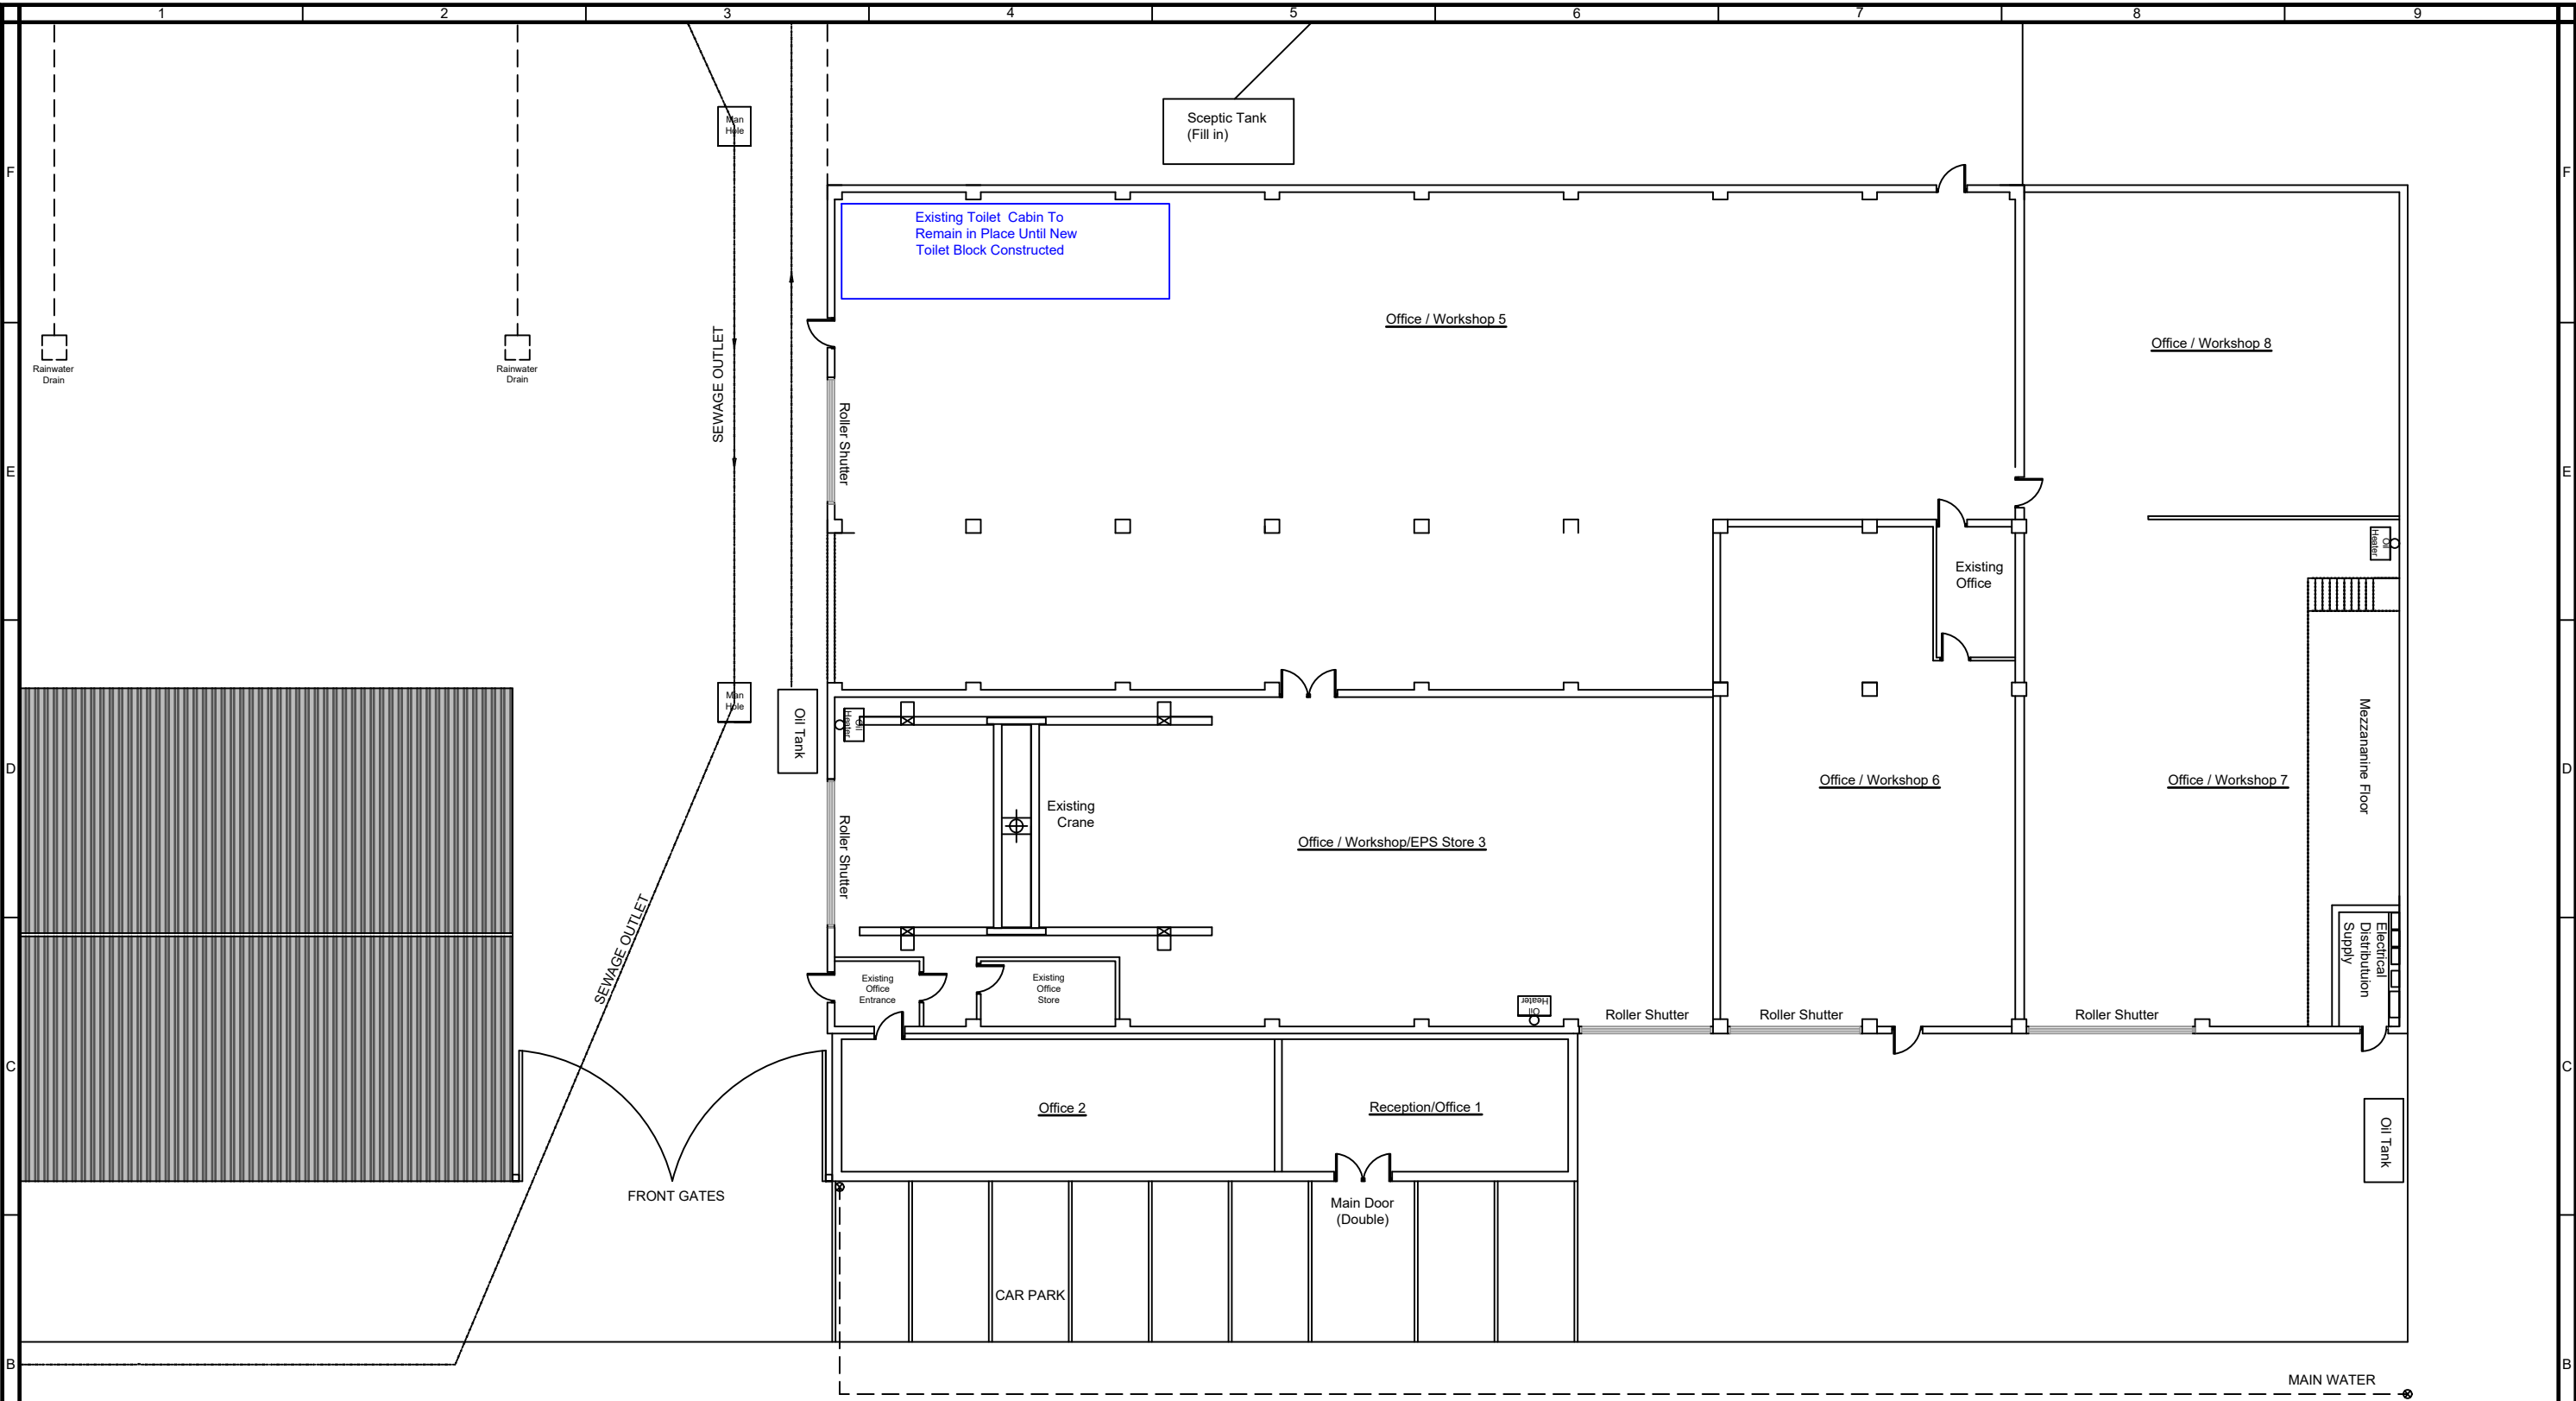

WAREHOUSE PLAN
SCALE 1:100@A1
0M 1M 2M 3M 4M 5M

REV		DATE		REVISIONS		Drawing Title	Description	Project Address	INF	DETAILS		CONTRACTOR	
A											Scale	1:100@A3	
B						Warehouse Plan	Existing Warehouse Plan	Steeple Essex	Drawn By	TDH			
C									Checked By B/I	TDH			
D									Checked By Client	~			
E									Date				
F									Drawing Number		PropWarePlan-01		
G													

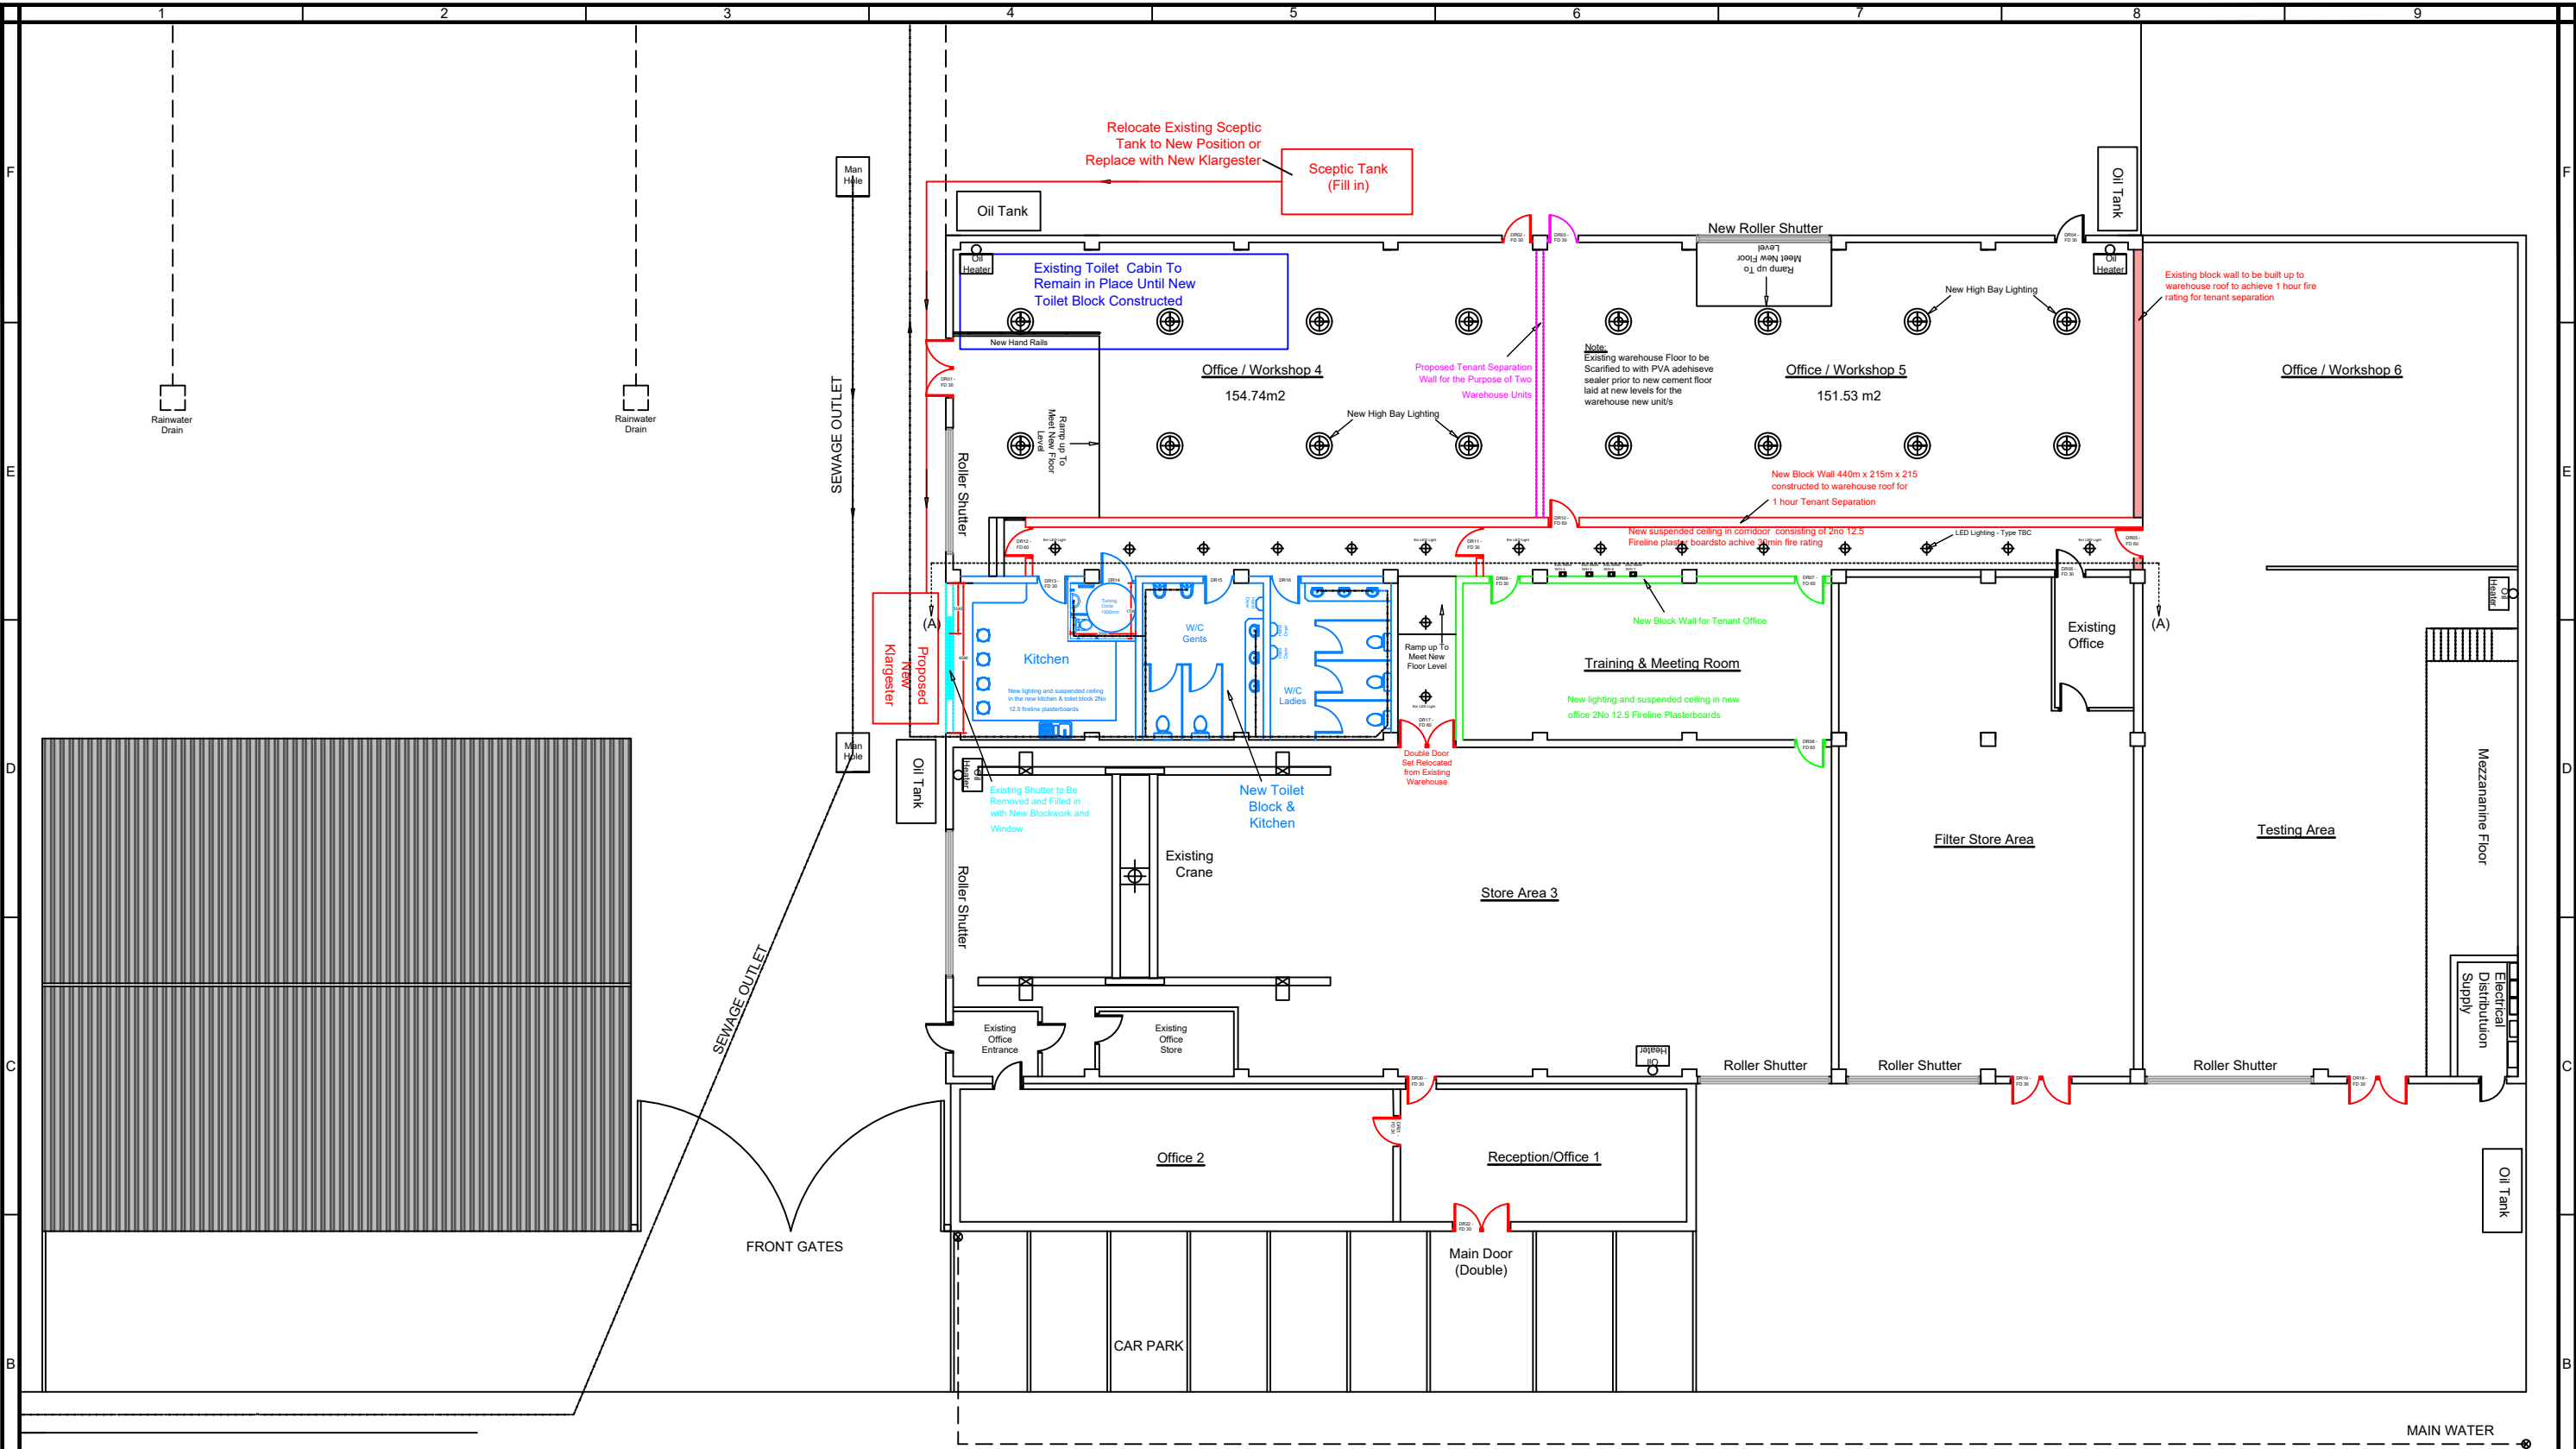


WAREHOUSE PLAN
SCALE 1:100@A1
0M 1M 2M 3M 4M 5M

REV		DATE	REVISIONS	Drawing Title	Description	Project Address	INF	DETAILS	CONTRACTOR
A							Proposed Warehouse Plan	Proposed Warehouse Conversion	Steeple Essex
B				Scale	1:100@A3				
C				Drawn By	TDH				
D				Checked By B/I	TDH				
E				Checked By Client	~				
F				Date					
G				Drawing Number PropWarePlan-01					

	9 Litre water Extinguisher
	9 Litre foam Extinguisher
	2kg Carbon Dioxide Extinguisher
	Fire Alarm Call Point (BS 5839)
	Area covered by smoke detector (BS5839)
	Area covered by heat detector (BS5839)
	Smoke Detector base sounder beacon
	Area covered by void smoke detection system (BS5839)
	Indicator for void detector
	Sign - 'FIRE DOOR KEEP SHUT' - 75MM letters
	Sign - 'FIRE DOOR KEEP LOCKED' - 75MM letters
	Sign - 'FIRE EXIT KEEP CLEAR' - 75MM letters
	Sign - Internally illuminated 'FIRE EXIT' - 75mm letters
	Area covered by alarm sounder (to be agreed on site)
	Strobe unit. Area covered visual alarm
	Area covered by emergency luminaire.
certificates of compliance to B.S. 5839 (Fire Alarms and/or B.S. 5266 (Emergency Lighting) to be provided by the fire authority	
VP	Vision Panel
	FD30S (Fitted with Automatic Closer)
	FD60S (Fitted with Automatic Closers)
	Push Bar to open door mechanism
	Fire Alarm Panel location TBC
	60 Minute Partition

1. Doors & partitions required to be fire resisting are to be in accordance with british standard B.S. 476.
2. Fire resisting doors required to resist the passage of smoke at ambient temperature conditions should, unless tested in accordance with B.S. 476 section 311, to be fitted with a smoke seal.
3. The fire alarm system is to comply with british standards B.S. 5839.
4. The emergency lighting installation is to comply to british standard 5266 Pt.1.
5. Illuminated 'EXIT' signs are to conform to British Standard B.S.2560
6. Fire Fighting Equipment to conform to British Standard B.S.5423
7. Fire Safety related signs & Notices are to conform to british standard B.S. 5449 Pt.1.
8. Wall & Ceiling linings are to be class 1 surface spread of flame (as defined in British Standard B.S. 476Pt 7) in non-public areas & class) (as defined in the building regulations) in routes of escape. (To include fixed furniture).
9. Upholstered seating Furniture should satisfy, as minimum standard, (ignition source), (cigarette test) specified in british standard B.S. 5852 Pt.1 @ Fire tests for furniture - methods of test for ignitability by smokers materials of upholstered composites for testing by flaming source 5 is the minimum requirement.
10. Any fabrics which have recieved a flame retardant tretment should be subjected to the water soak test detailed in british standard B.S. 5651 independant certification to the above standards should be provided from accreditation test organisation.

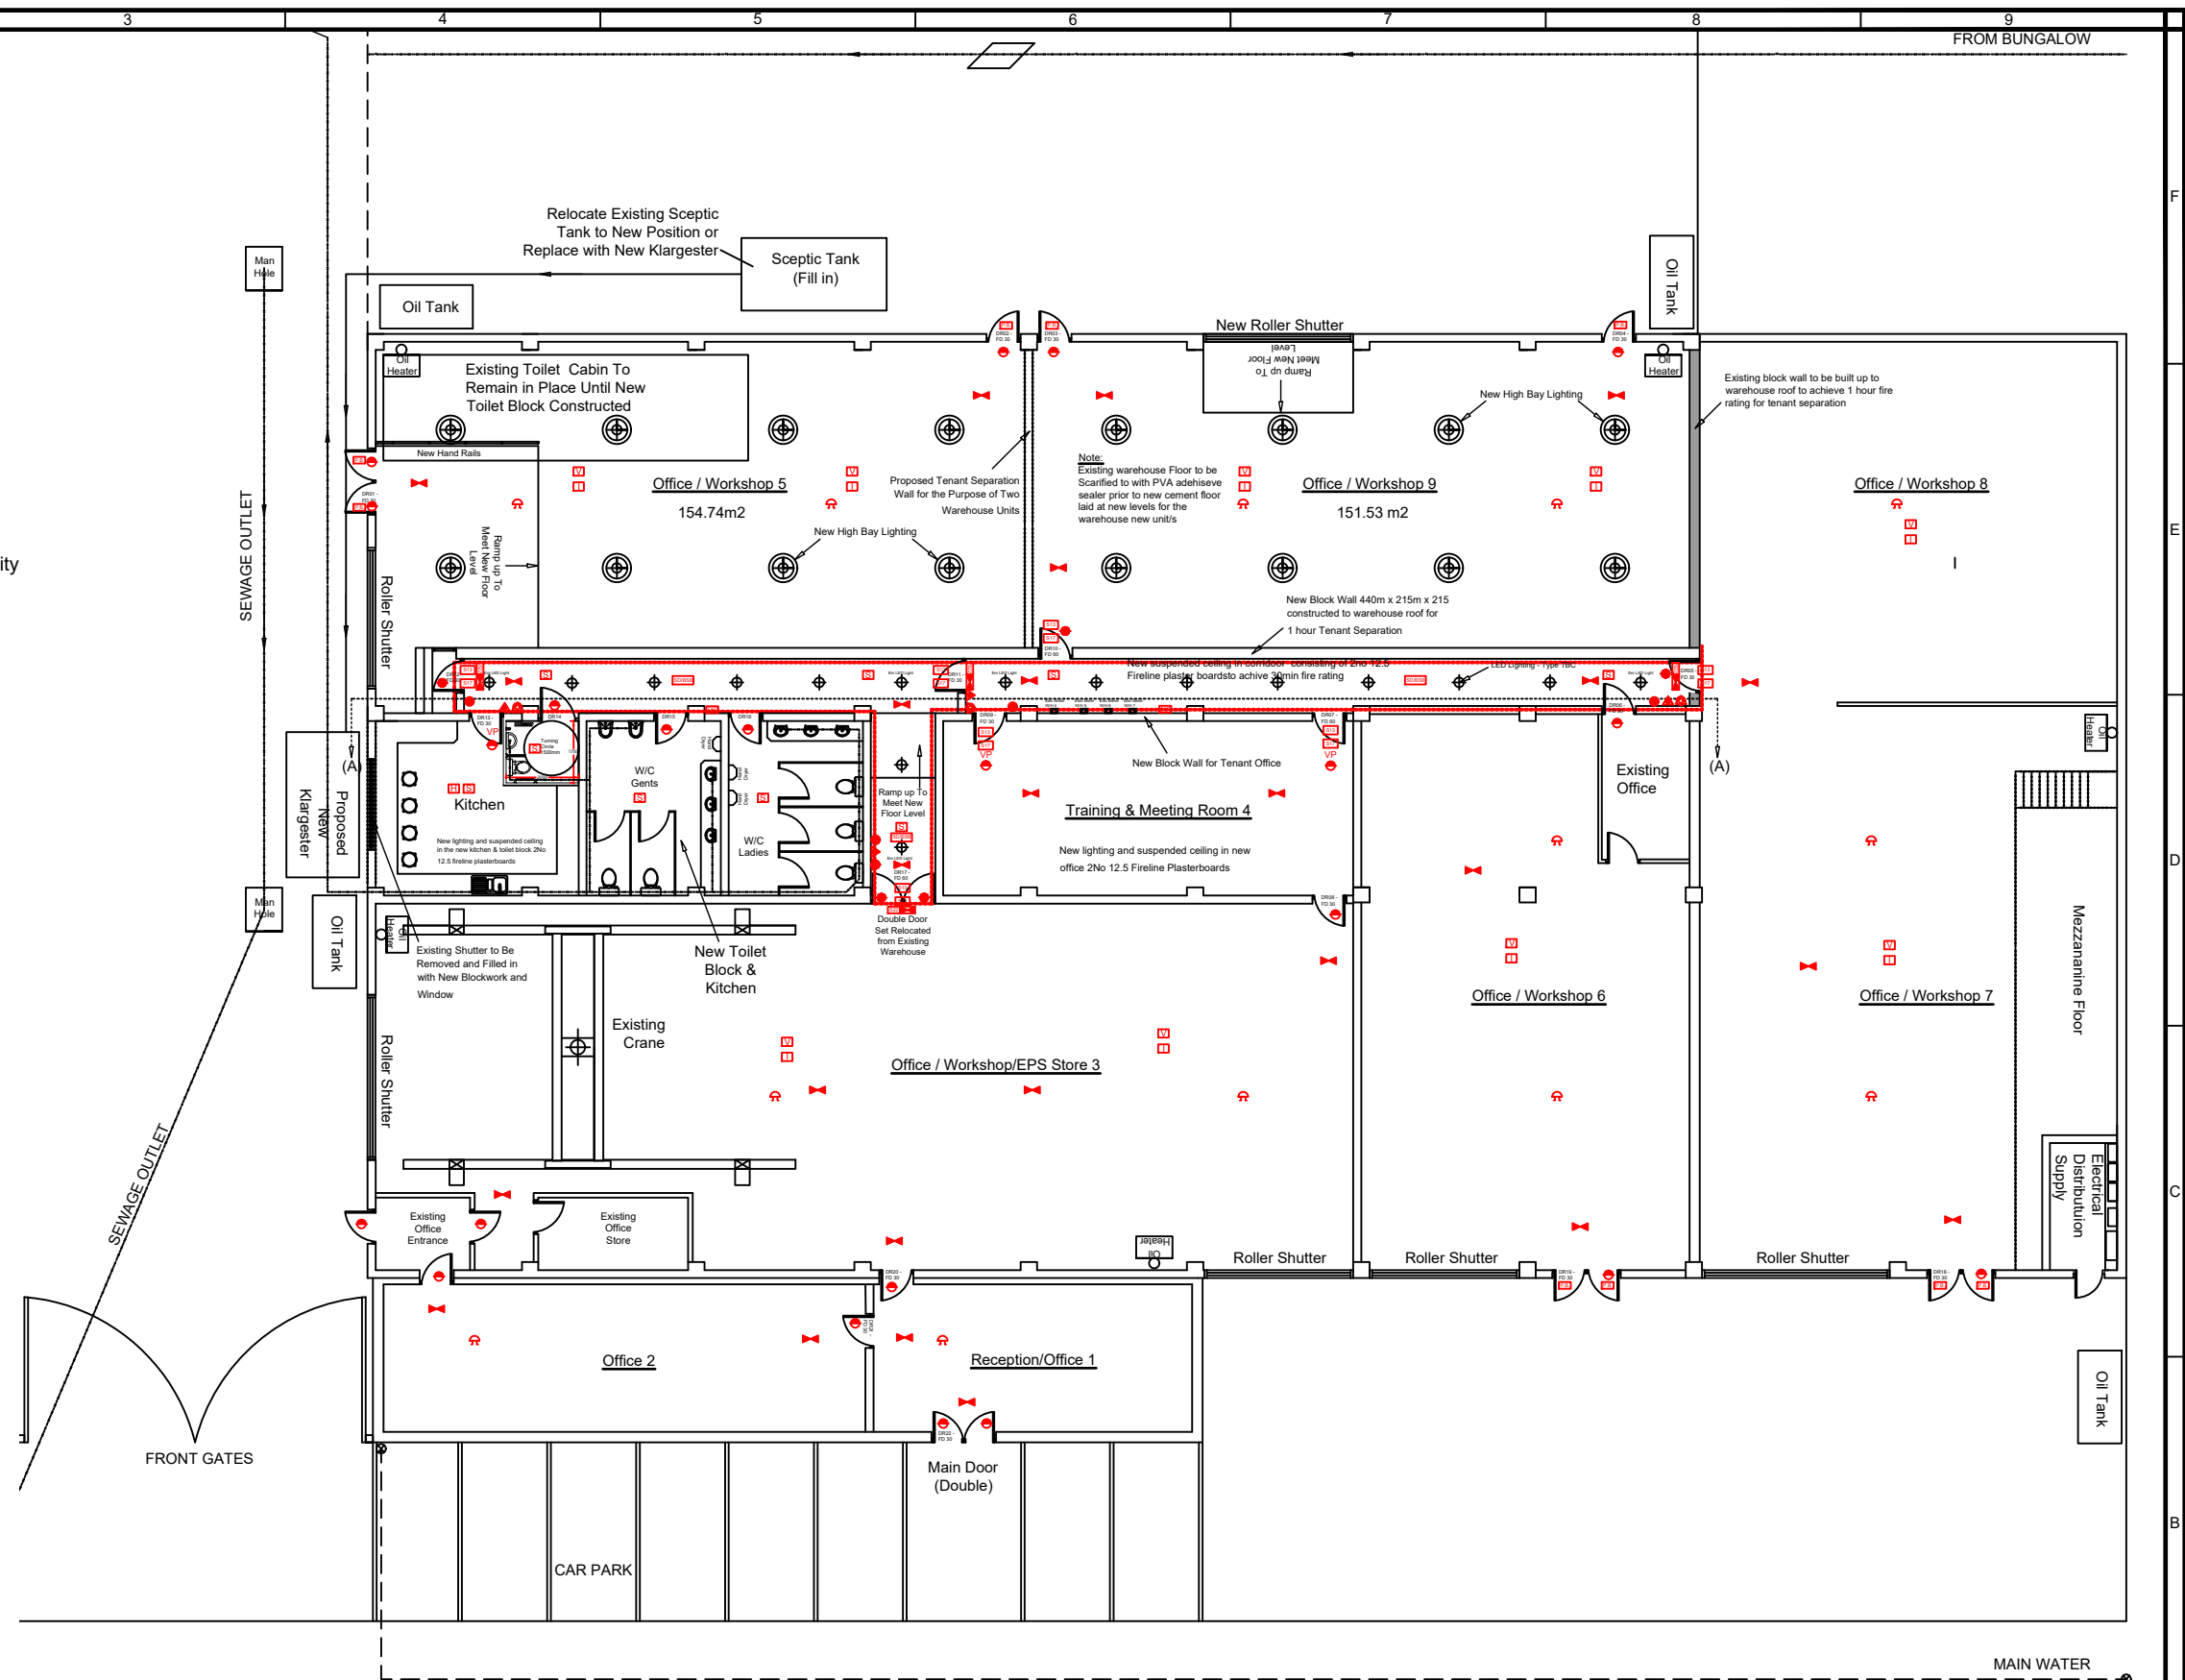


WAREHOUSE PLAN


SCALE 1:100@A1

REV	DATE	REVISIONS	Drawing Title	Description	Project Address	INF	DETAILS	CONTRACTOR
A			Proposed Warehouse Fire Plan	Proposed Warehouse Conversion	Steeple Essex			 ARCHITECTURE enquiries@sxarchitecture.co.uk THIS DRAWING IS THE COPYRIGHT OF SX-ARCHITECTURE AND MUST NOT BE COPIED OR REPRODUCED, IN WHOLE OR IN PART, BY ANY METHOD WHATSOEVER, WITHOUT THE PRIOR WRITTEN AGREEMENT OF SX-ARCHITECTURE
B						Scale	1:100@A3	
C						Drawn By	TDH	
D						Checked By B/I	TDH	
E						Checked By Client	~	
F						Date		
G						Drawing Number PropWarePlan-01		

THIS DRAWING IS THE COPYRIGHT OF SX-ARCHITECTURE AND MUST NOT BE COPIED OR REPRODUCED, IN WHOLE OR IN PART, BY ANY METHOD WHATSOEVER, WITHOUT THE PRIOR WRITTEN APPROVAL OF SX-ARCHITECTURE.

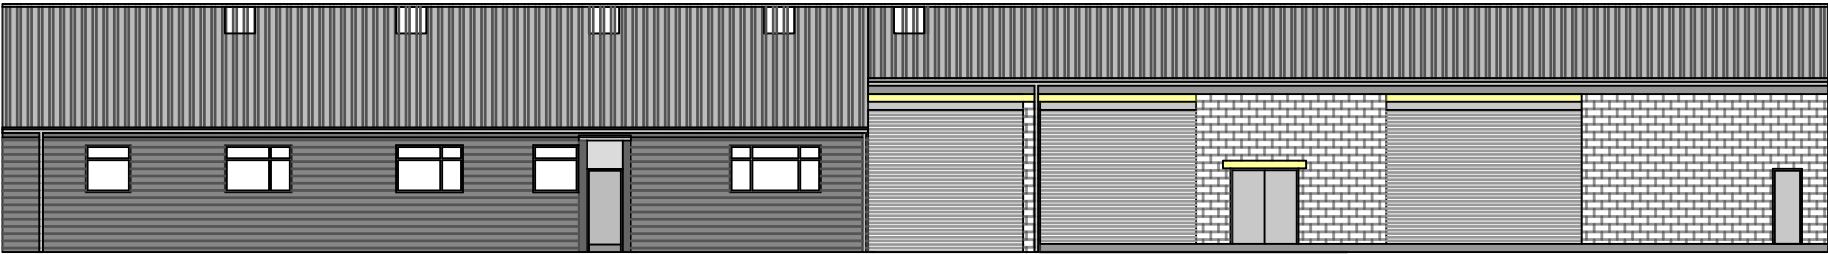

Existing - South Facing Elevation

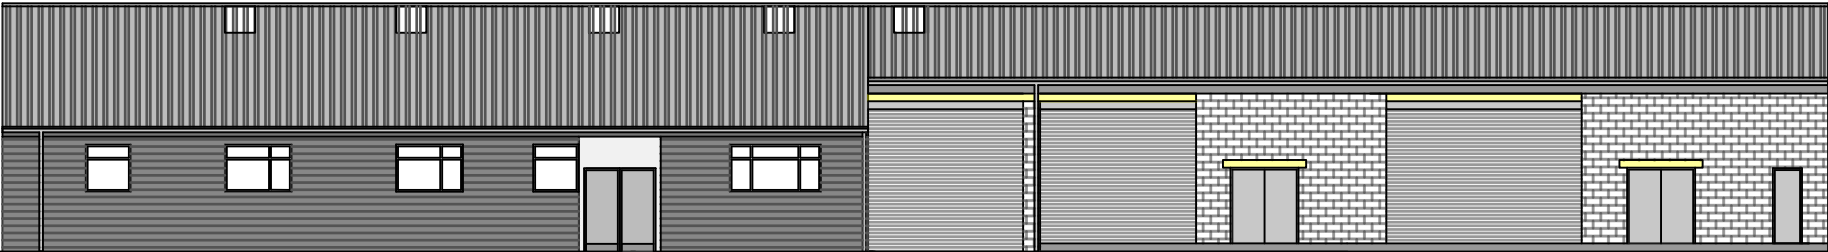


Proposed - South Facing Elevation


ELEVATION

SCALE 1:100@A1
0M 1M 2M 3M 4M 5M

REV	DATE	REVISIONS	Drawing Title	Description	Project Address	INF	DETAILS	CONTRACTOR
A			Proposed South Elevation	Warehouse Conversion	Steeple Essex			SX  ARCHITECTURE enquiries@sxarchitecture.co.uk THIS DRAWING IS THE COPYRIGHT OF SX ARCHITECTURE AND MUST NOT BE COPIED OR REPRODUCED, IN WHOLE OR IN PART, BY ANY METHOD WHATSOEVER, WITHOUT THE PRIOR WRITTEN APPROVAL OF SX ARCHITECTURE.
B						Scale	1:2@A3	
C						Drawn By	TDH	
D						Checked By B/I	TDH	
E						Checked By Client	~	
F						Date		
G						Drawing Number EPS-WestElev-01		

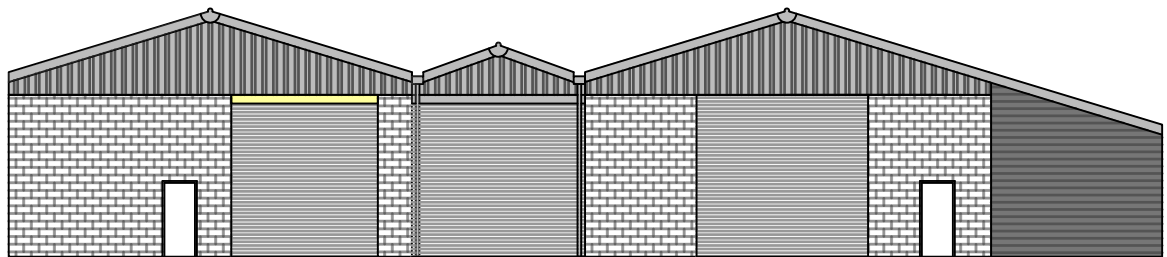


Existing - West Facing Elevation

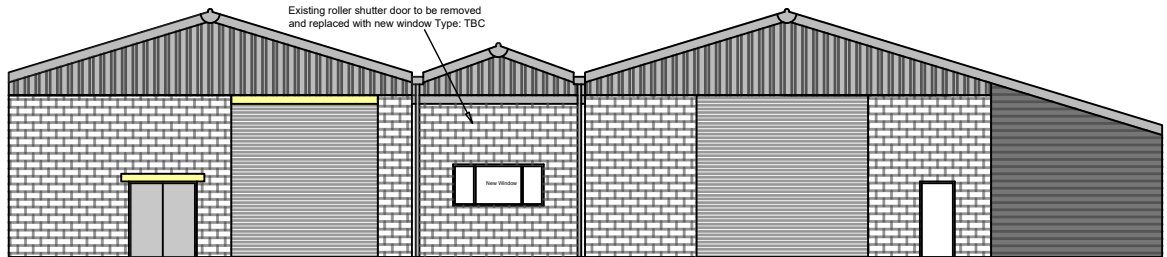


Proposed - West Facing Elevation

ELEVATION

 SCALE 1:100@A1



REV	DATE	REVISIONS	Drawing Title	Description	Project Address	INF	DETAILS	CONTRACTOR
A			Proposed West Elevation	Warehouse Conversion	Eastern Petroleum Steeple Essex CM0 7RR	Scale	1:2@A3	SX  ARCHITECTURE enquiries@sxarchitecture.co.uk THIS DRAWING IS THE COPYRIGHT OF SX-ARCHITECTURE AND MUST NOT BE COPIED OR REPRODUCED, IN WHOLE OR IN PART, BY ANY METHOD WHATSOEVER, WITHOUT THE PRIOR WRITTEN APPROVAL OF SX-ARCHITECTURE.
B						Drawn By	TDH	
C						Checked By B/I	TDH	
D						Checked By Client	~	
E						Date		
F						Drawing Number		
G						SouthElev-01		

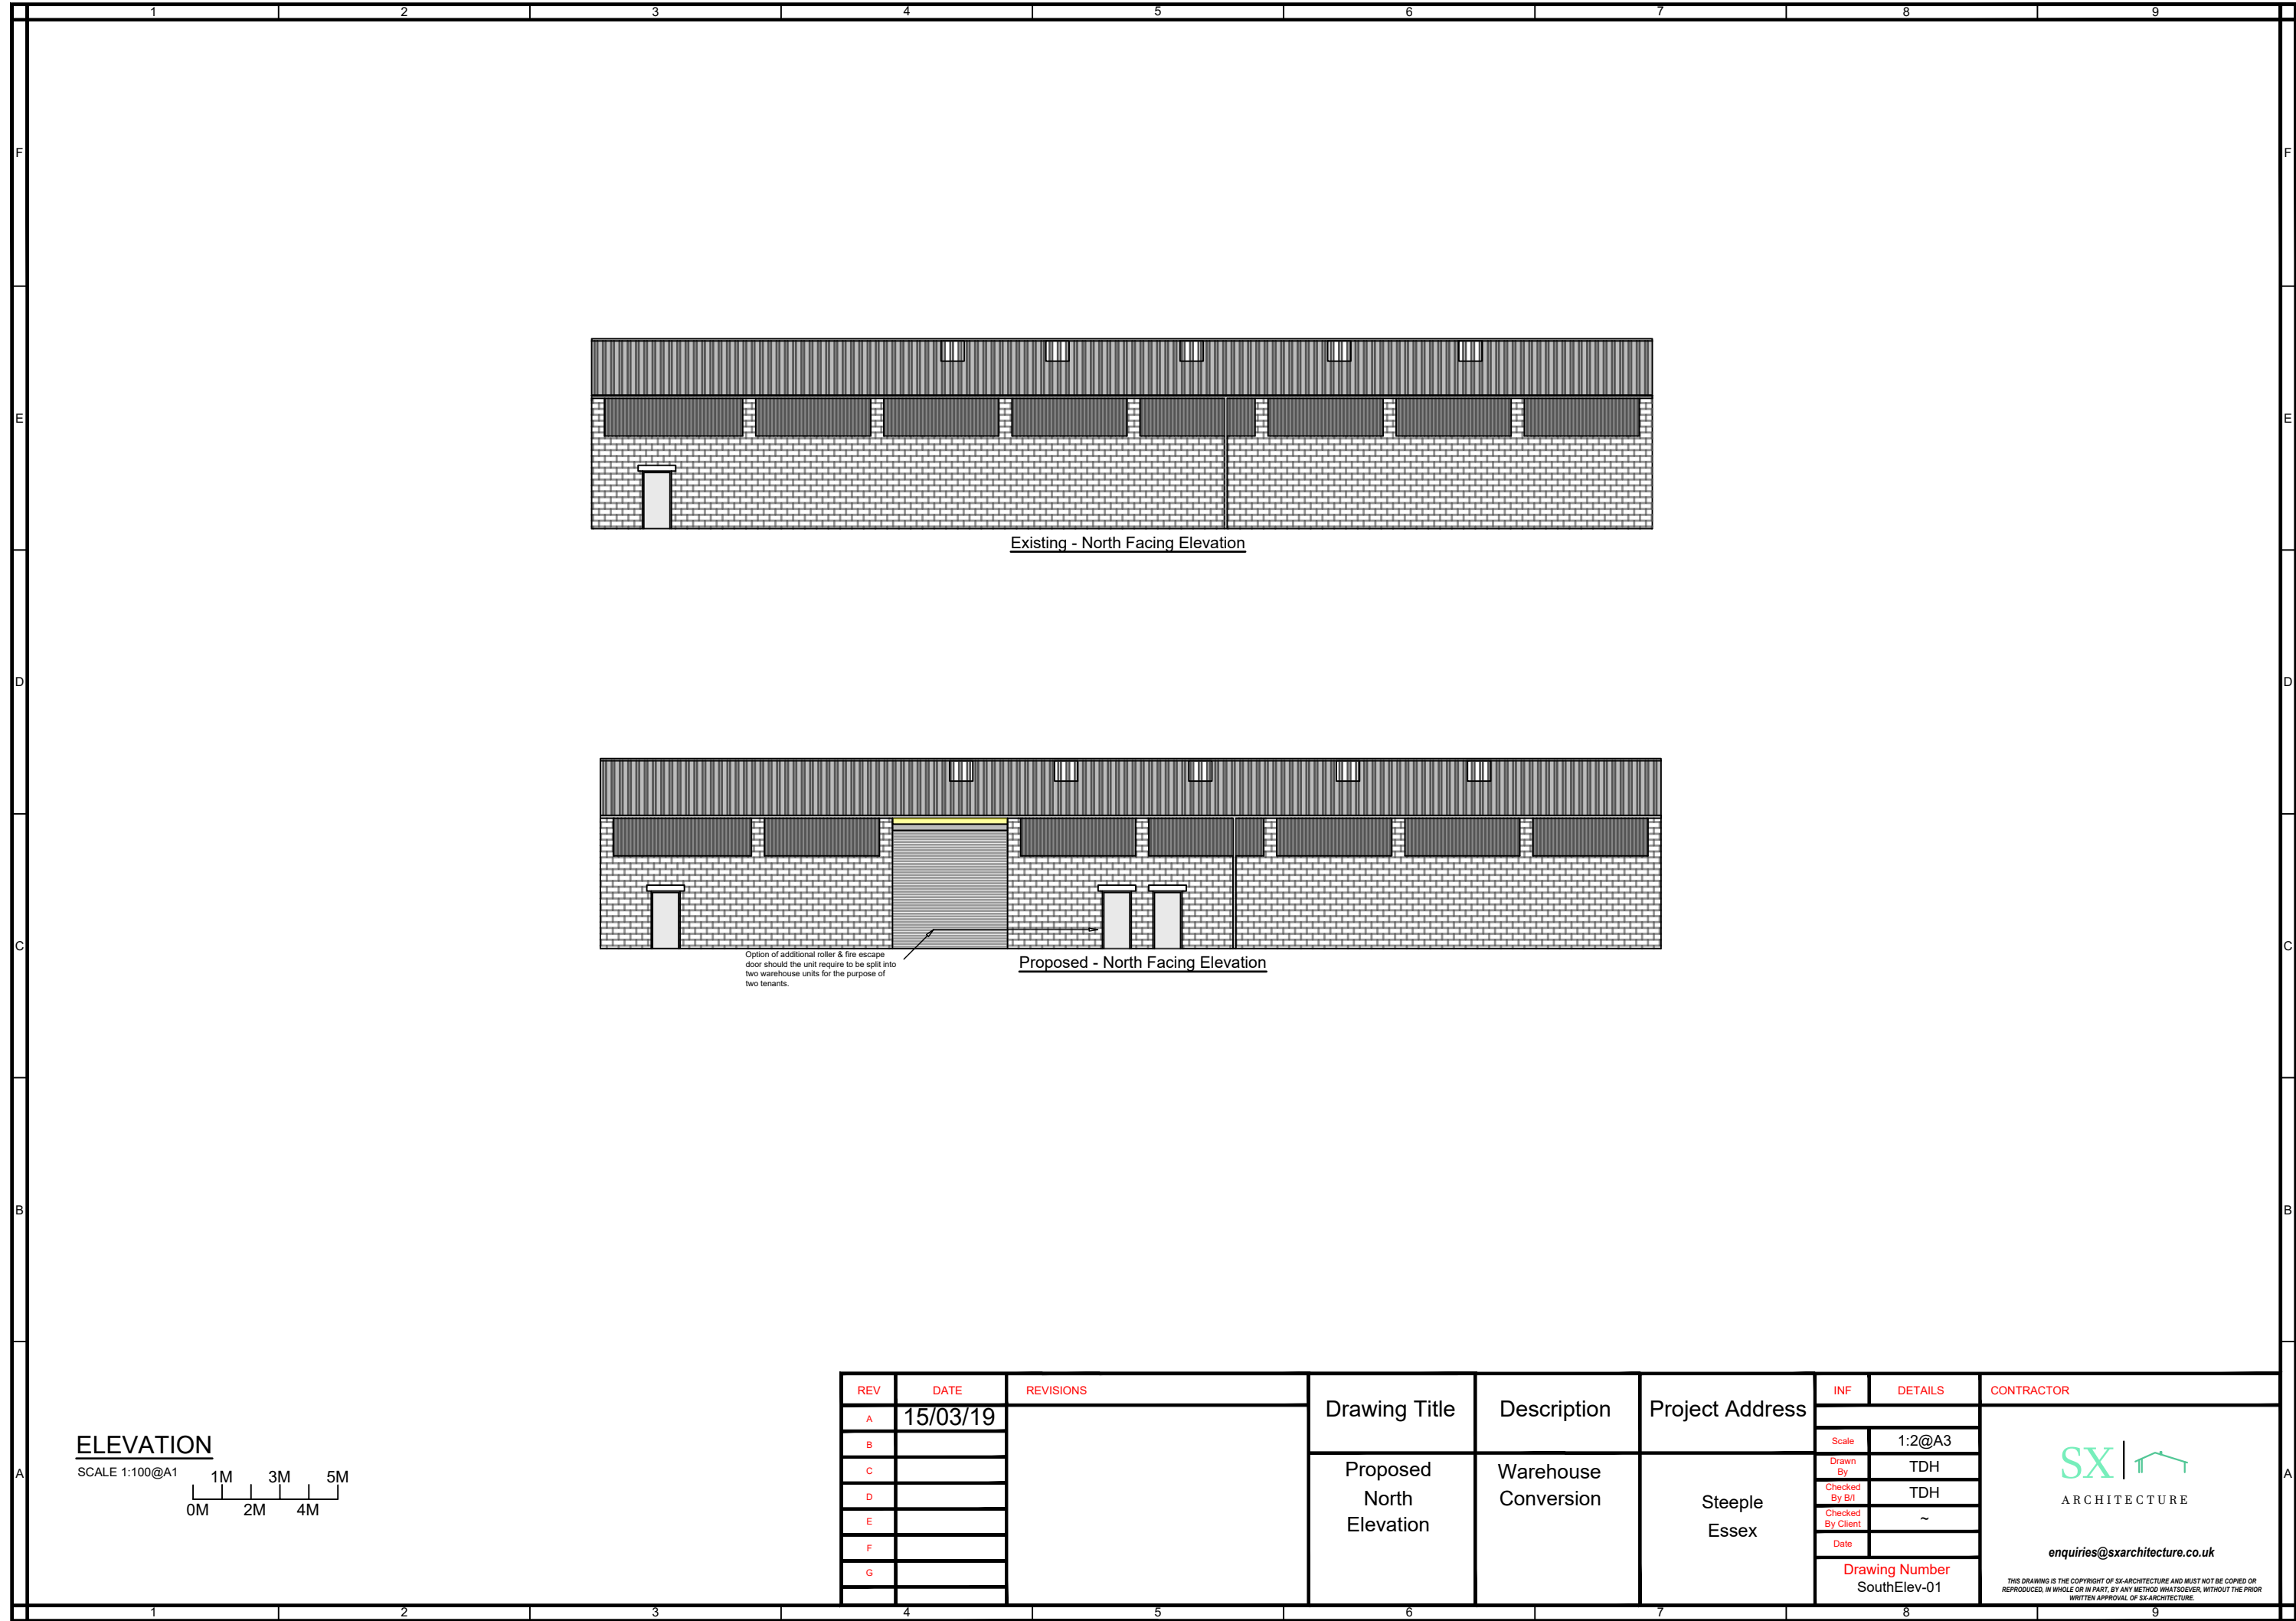


ELEVATION

SCALE 1:100@A1


0M 1M 2M 3M 4M 5M

REV	DATE	REVISIONS	Drawing Title	Description	Project Address	INF	DETAILS	CONTRACTOR
A	15/03/19							
B						Scale	1:2@A3	
C						Drawn By	TDH	
D						Checked By B/I	TDH	
E						Checked By Client	~	
F						Date		
G								
			Proposed North Elevation	Warehouse Conversion	Steeple Essex		Drawing Number SouthElev-01	
								SX ARCHITECTURE enquiries@sxarchitecture.co.uk THIS DRAWING IS THE COPYRIGHT OF SX ARCHITECTURE AND MUST NOT BE COPIED OR REPRODUCED, IN WHOLE OR IN PART, BY ANY METHOD WHATSOEVER, WITHOUT THE PRIOR WRITTEN APPROVAL OF SX ARCHITECTURE.

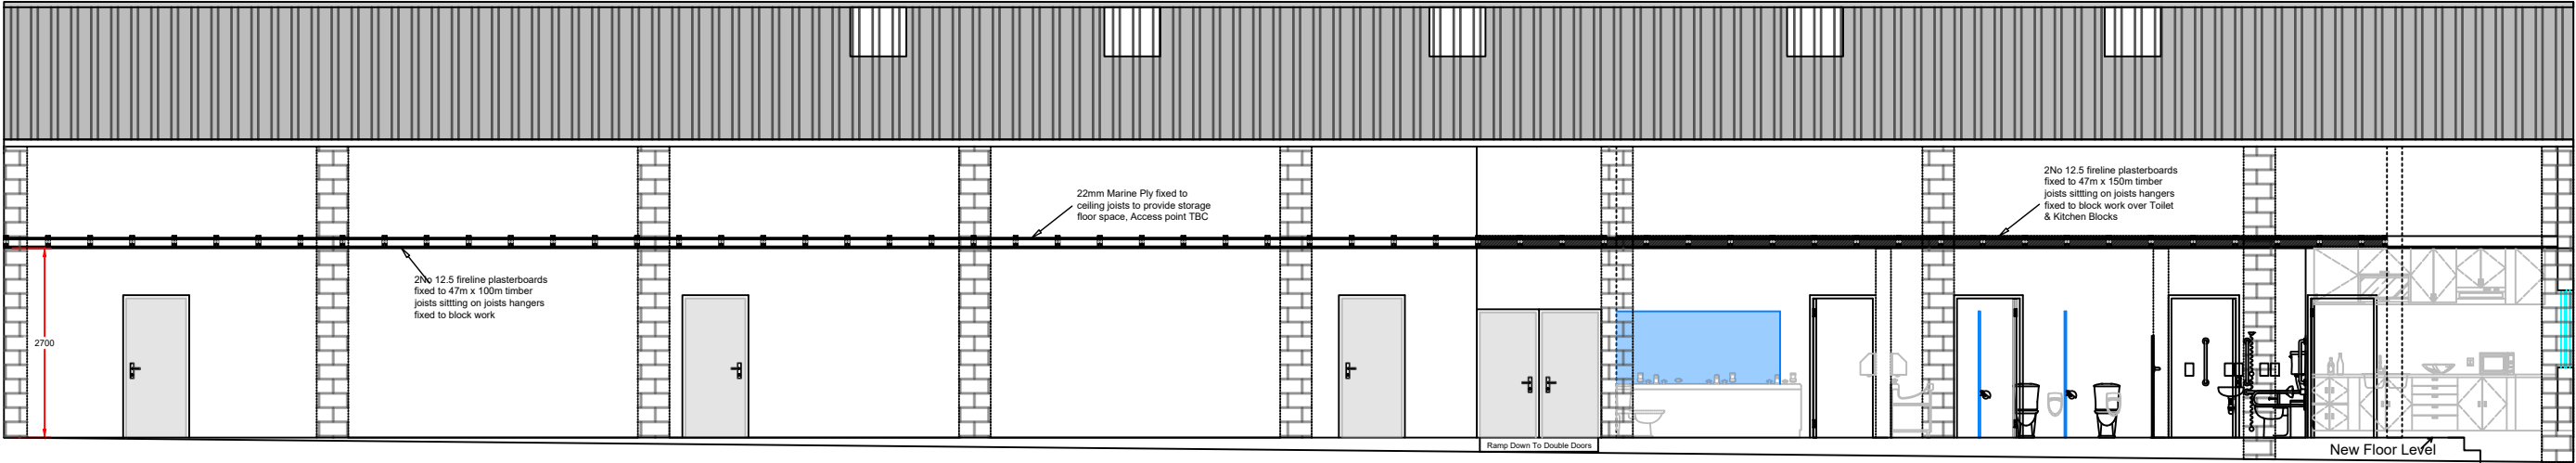

Proposed Section (A)-(A) - North Facing Elevation

ELEVATION

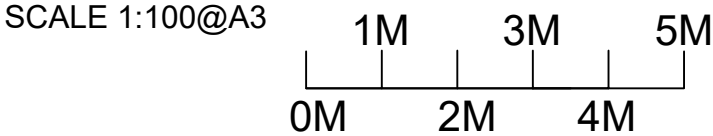

REV	DATE	REVISIONS	Drawing Title	Description	Project Address	INF	DETAILS	CONTRACTOR
A						Scale	1:100@A3	
B						Drawn By	TDH	
C						Checked By B/I	TDH	
D						Checked By Client	~	
E						Date		
F						Drawing Number	SectElev-01	
G								

SX | 

ARCHITECTURE

enquiries@sxarchitecture.co.uk

THIS DRAWING IS THE COPYRIGHT OF SX ARCHITECTURE AND MUST NOT BE COPIED OR REPRODUCED, IN WHOLE OR IN PART, BY ANY METHOD WHATSOEVER, WITHOUT THE PRIOR WRITTEN APPROVAL OF SX ARCHITECTURE.

